


Architecture Plan

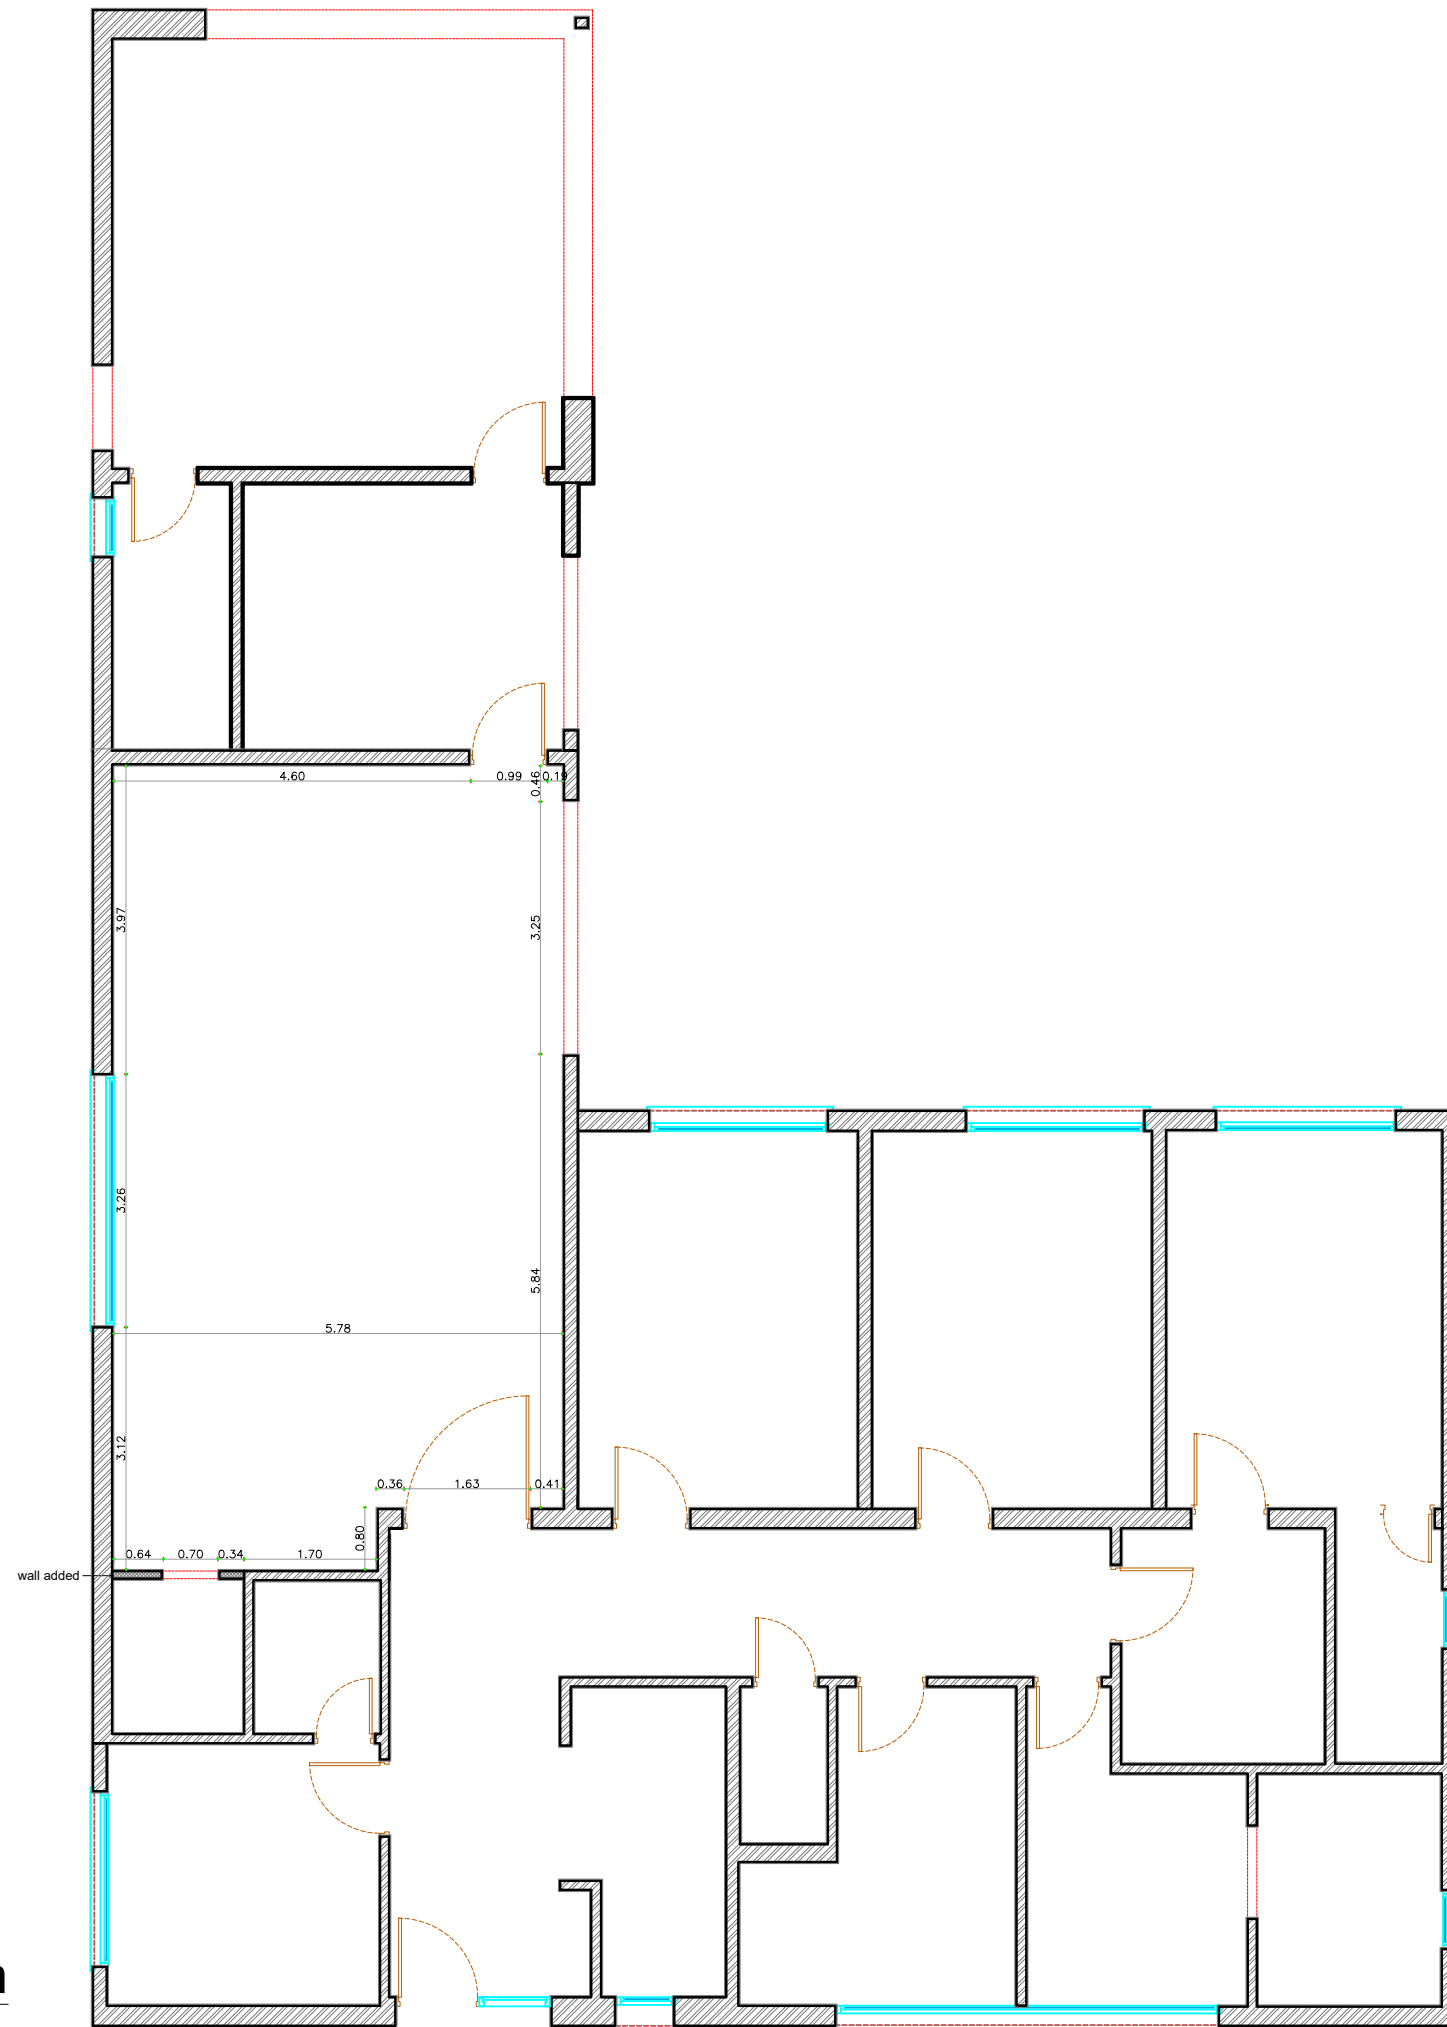

GENERAL NOTES

1. ALL DIMENSIONS ARE IN METERS UNLESS OTHERWISE STATED.
2. VERIFY THE ARCHITECT WHENEVER DISCREPANCIES ARE FOUND BETWEEN DRAWINGS AND SPECIFICATIONS.
3. DO NOT SCALE FROM THIS DRAWING, WORK TO FIGURE DIMENSIONS ONLY.
4. COMPLETE WORKING DRAWINGS SHALL BE SUBMITTED BY THE CONTRACTOR FOR CONSULTANT APPROVAL BEFORE EXECUTION.
5. DRAWING TO BE READ IN CO-ORDINATION AND IN CONJUNCTION WITH ALL RELEVANT SPECIFICATIONS AND CROSS DISCIPLINE ENGINEERING DRAWINGS INCLUDING LANDSCAPING.
6. ALL ELECTRO-MECHANICAL WORKS SHALL BE COORDINATED WITH ARCHITECTURAL ELEMENTS IN THESE DRAWING (MASONRY, FLOORING, CEILING, OPENINGS, LIGHTING, ETC.)
7. CONTRACTOR SHALL SUBMIT FINISHING MATERIAL SAMPLES FOR CONSULTANT APPROVAL BEFORE EXECUTION.

REVISIONS:

NO.	DECRPTION	DATE

CLIENT: -


PROJECT: -

LOCATION: -

DRAWING TITLE: -

DATE: -	SHEET 1
SCALE: -	

Wall Decorations Plan

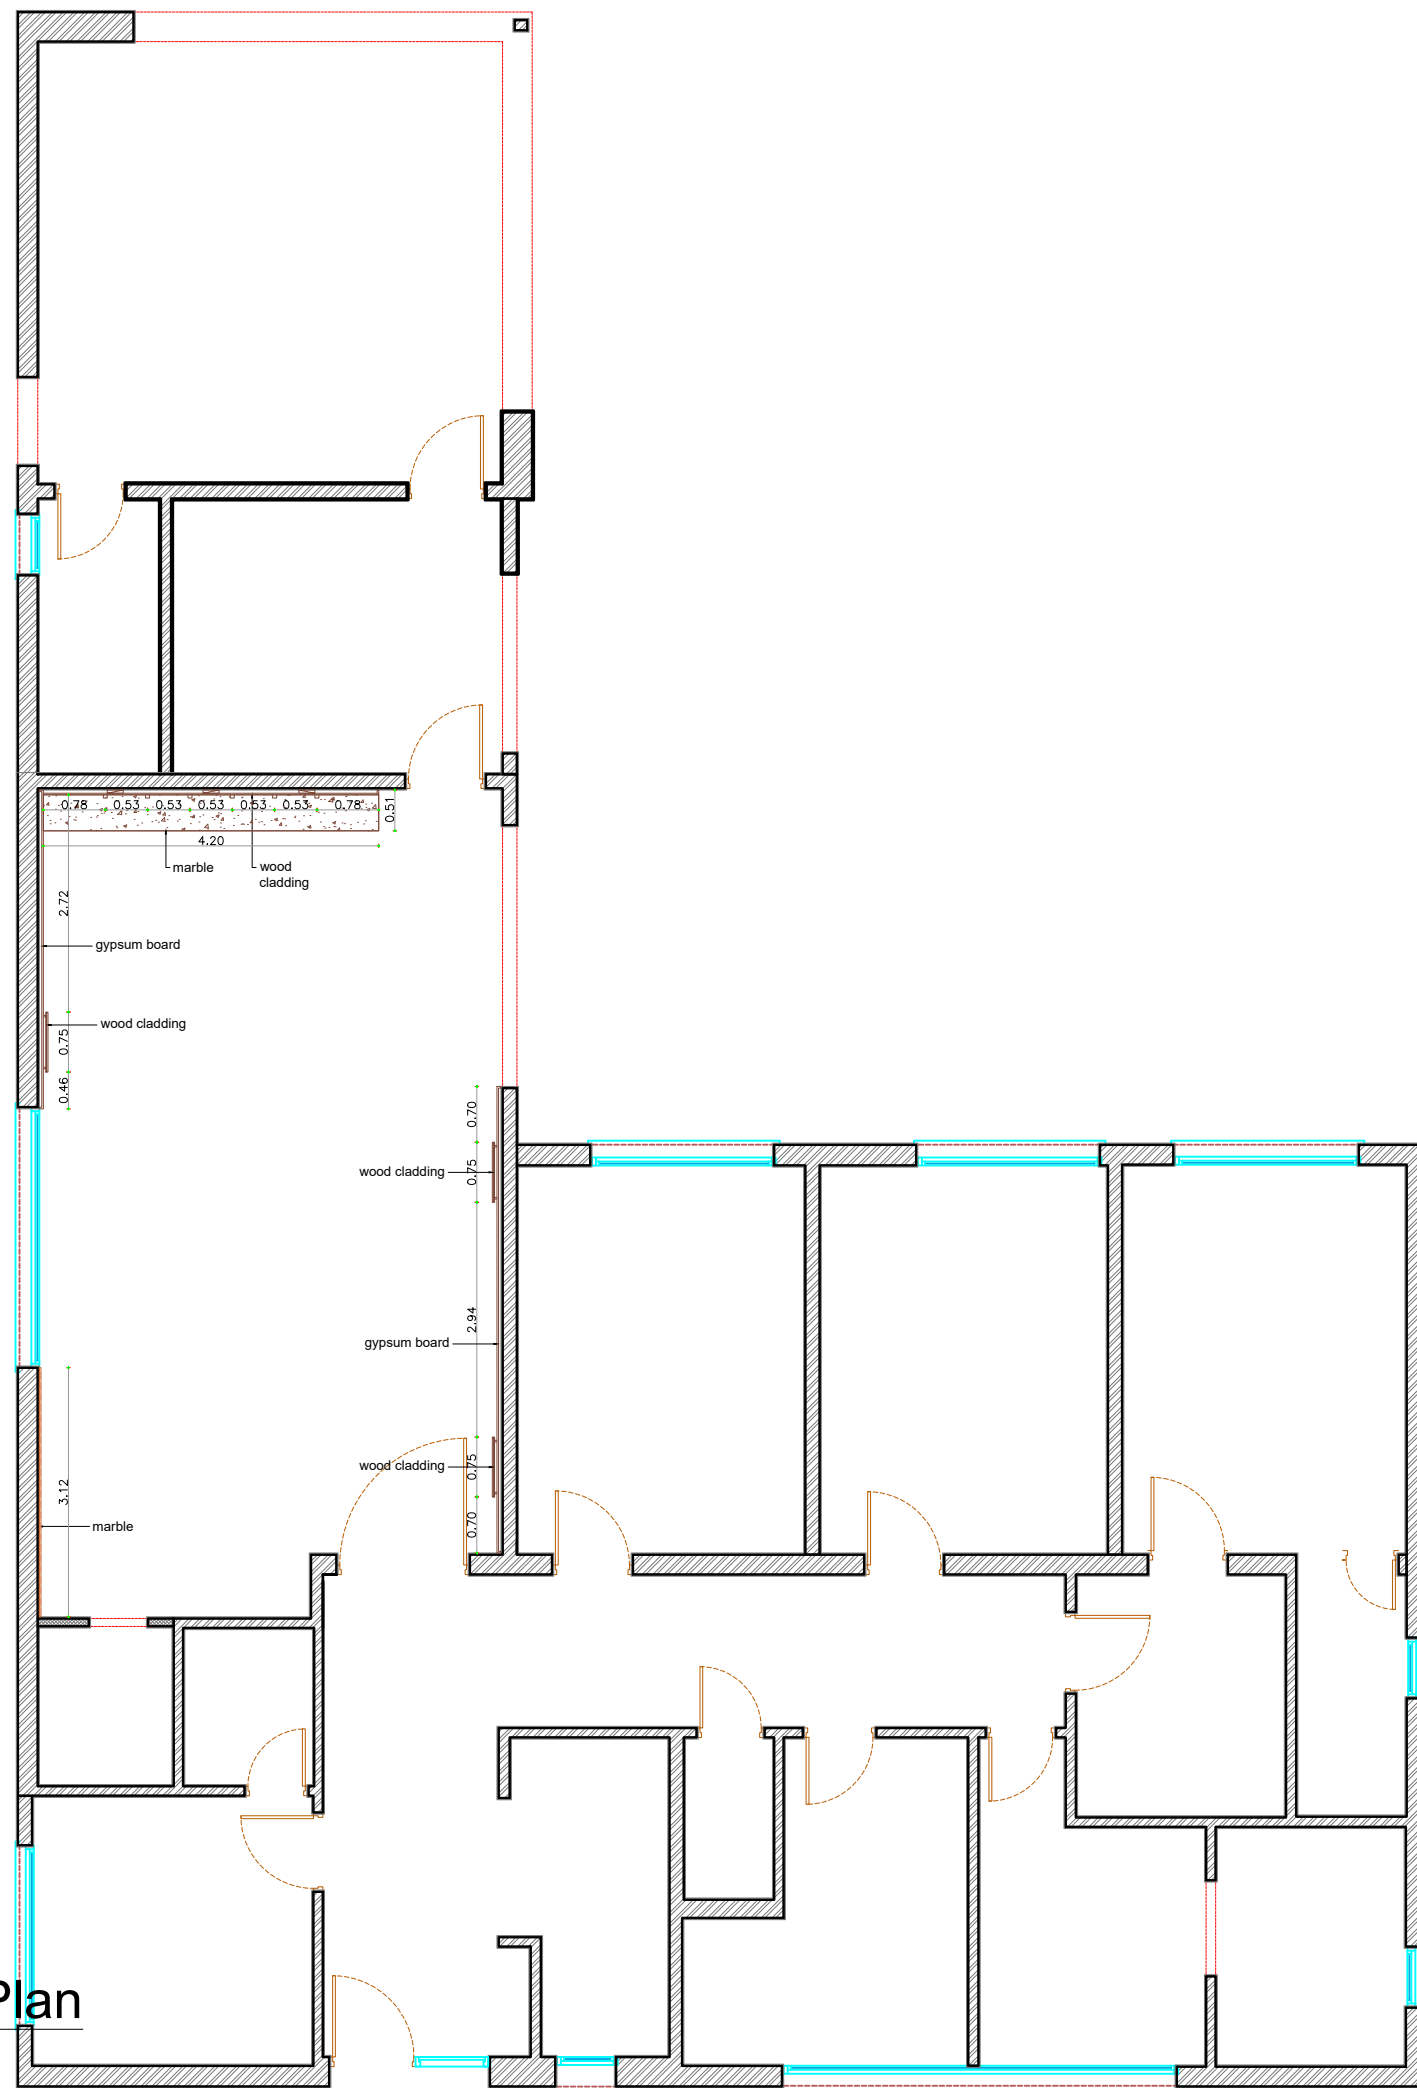

GENERAL NOTES

1. ALL DIMENSIONS ARE IN METERS UNLESS OTHERWISE STATED.
2. VERIFY THE ARCHITECT WHENEVER DISCREPANCIES ARE FOUND BETWEEN DRAWINGS AND SPECIFICATIONS.
3. DO NOT SCALE FROM THIS DRAWING, WORK TO FIGURE DIMENSIONS ONLY.
4. COMPLETE WORKING DRAWINGS SHALL BE SUBMITTED BY THE CONTRACTOR FOR CONSULTANT APPROVAL BEFORE EXECUTION.
5. DRAWING TO BE READ IN CO-ORDINATION AND IN CONJUNCTION WITH ALL RELEVANT SPECIFICATIONS AND CROSS DISCIPLINE ENGINEERING DRAWINGS INCLUDING LANDSCAPING.
6. ALL ELECTRO-MECHANICAL WORKS SHALL BE COORDINATED WITH ARCHITECTURAL ELEMENTS IN THESE DRAWING (MASONRY, FLOORING, CEILING, OPENINGS, LIGHTING, ETC.)
7. CONTRACTOR SHALL SUBMIT FINISHING MATERIAL SAMPLES FOR CONSULTANT APPROVAL BEFORE EXECUTION.

REVISIONS:

NO.	DESCRIPTION	DATE

CLIENT: -


PROJECT: -

LOCATION: -

DRAWING TITLE: -

DATE: -	SHEET 2
SCALE: -	

Furniture Plan

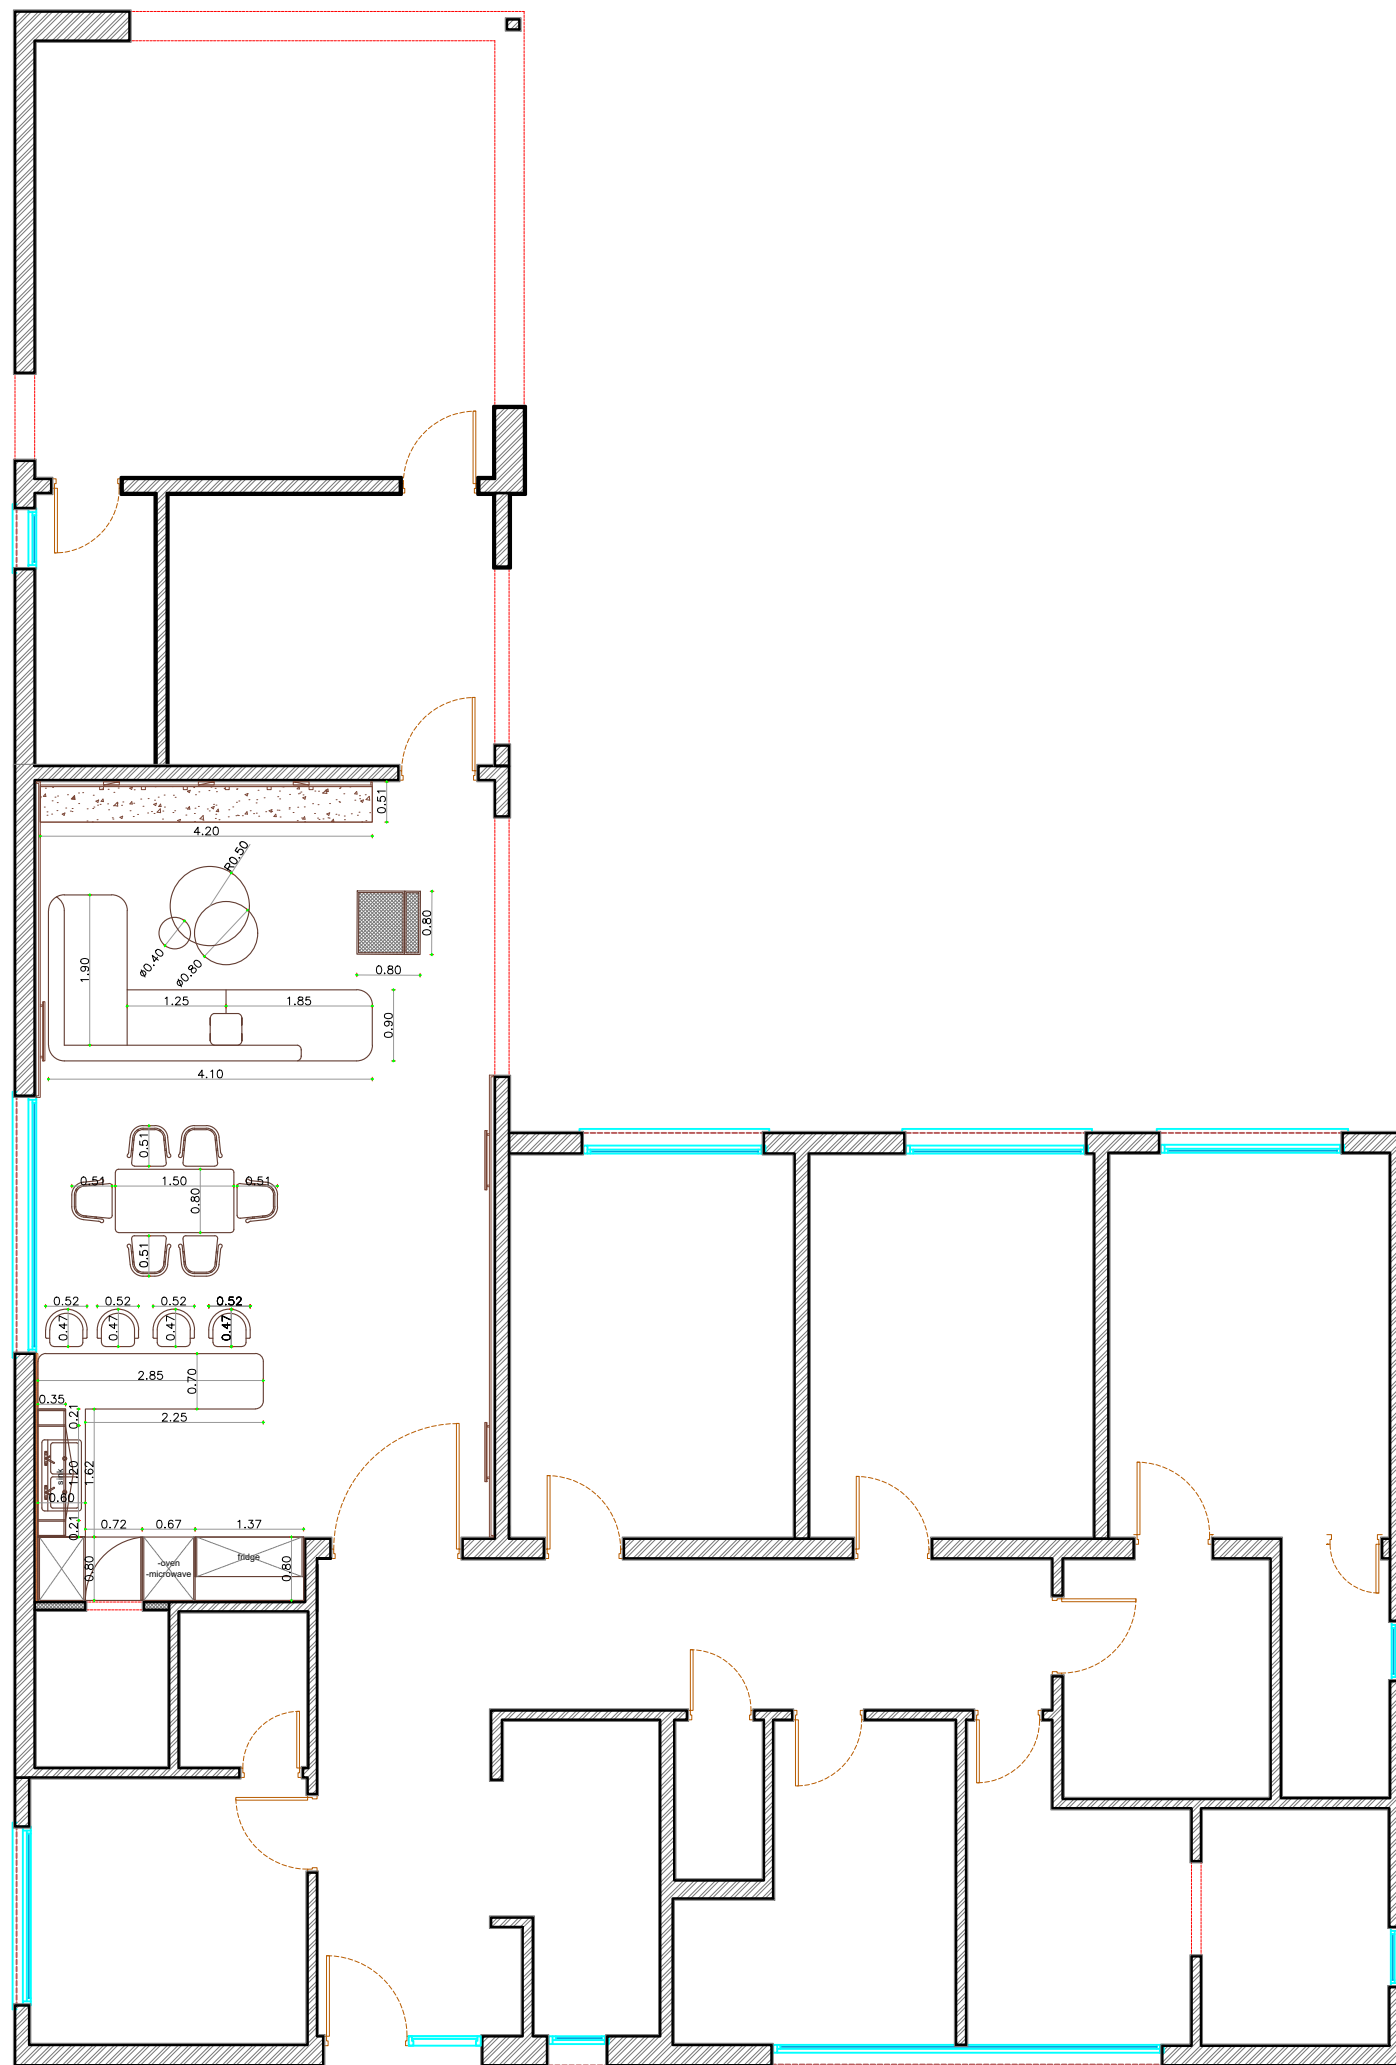

GENERAL NOTES

1. ALL DIMENSIONS ARE IN METERS UNLESS OTHERWISE STATED.
2. VERIFY THE ARCHITECT WHENEVER DISCREPANCIES ARE FOUND BETWEEN DRAWINGS AND SPECIFICATIONS.
3. DO NOT SCALE FROM THIS DRAWING, WORK TO FIGURE DIMENSIONS ONLY.
4. COMPLETE WORKING DRAWINGS SHALL BE SUBMITTED BY THE CONTRACTOR FOR CONSULTANT APPROVAL BEFORE EXECUTION.
5. DRAWING TO BE READ IN CO-ORDINATION AND IN CONJUNCTION WITH ALL RELEVANT SPECIFICATIONS AND CROSS DISCIPLINE ENGINEERING DRAWINGS INCLUDING LANDSCAPING.
6. ALL ELECTRO-MECHANICAL WORKS SHALL BE COORDINATED WITH ARCHITECTURAL ELEMENTS IN THESE DRAWING (MASONRY, FLOORING, CEILING, OPENINGS, LIGHTING, ETC.)
7. CONTRACTOR SHALL SUBMIT FINISHING MATERIAL SAMPLES FOR CONSULTANT APPROVAL BEFORE EXECUTION.

REVISIONS:

NO.	DESCRIPTION	DATE

CLIENT: -


PROJECT: -

LOCATION: -

DRAWING TITLE: -

DATE: -	SHEET 3
SCALE: -	

Ceiling Plan

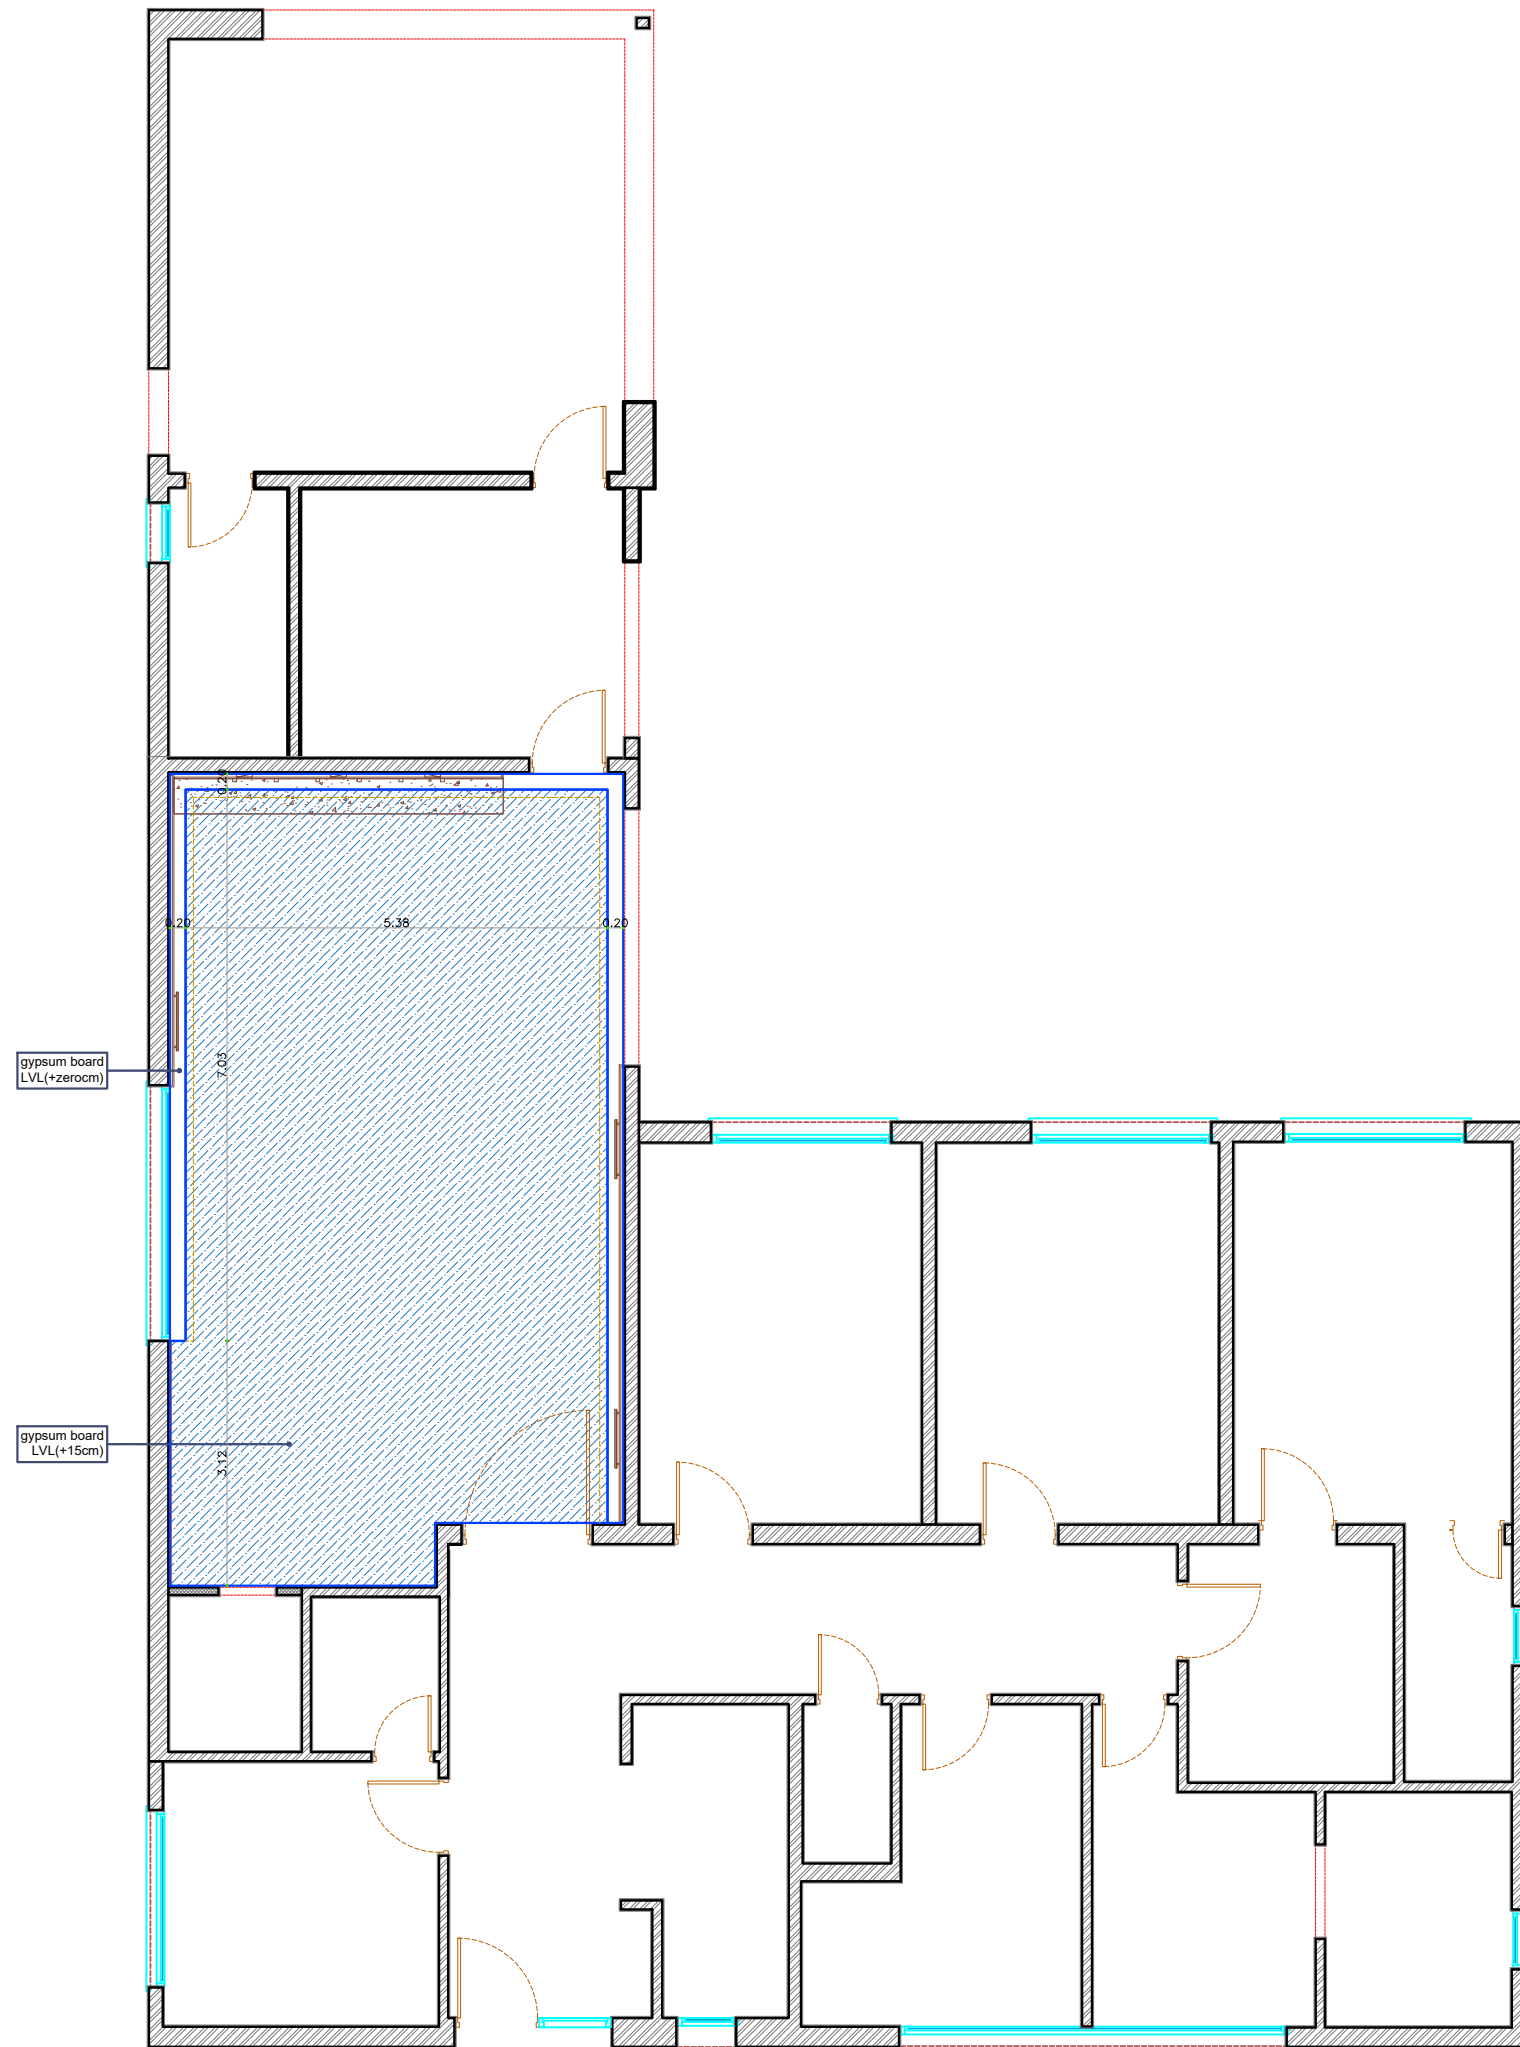

GENERAL NOTES

1. ALL DIMENSIONS ARE IN METERS UNLESS OTHERWISE STATED.
2. VERIFY THE ARCHITECT WHENEVER DISCREPANCIES ARE FOUND BETWEEN DRAWINGS AND SPECIFICATIONS.
3. DO NOT SCALE FROM THIS DRAWING, WORK TO FIGURE DIMENSIONS ONLY.
4. COMPLETE WORKING DRAWINGS SHALL BE SUBMITTED BY THE CONTRACTOR FOR CONSULTANT APPROVAL BEFORE EXECUTION.
5. DRAWING TO BE READ IN CO-ORDINATION AND IN CONJUNCTION WITH ALL RELEVANT SPECIFICATIONS AND CROSS DISCIPLINE ENGINEERING DRAWINGS INCLUDING LANDSCAPING.
6. ALL ELECTRO-MECHANICAL WORKS SHALL BE COORDINATED WITH ARCHITECTURAL ELEMENTS IN THESE DRAWING (MASONRY, FLOORING, CEILING, OPENINGS, LIGHTING, ETC.)
7. CONTRACTOR SHALL SUBMIT FINISHING MATERIAL SAMPLES FOR CONSULTANT APPROVAL BEFORE EXECUTION.

REVISIONS:

NO.	DECRPTION	DATE


CLIENT: -

PROJECT: -

LOCATION: -

DRAWING TITLE: -

DATE: -	SHEET 4
SCALE: -	

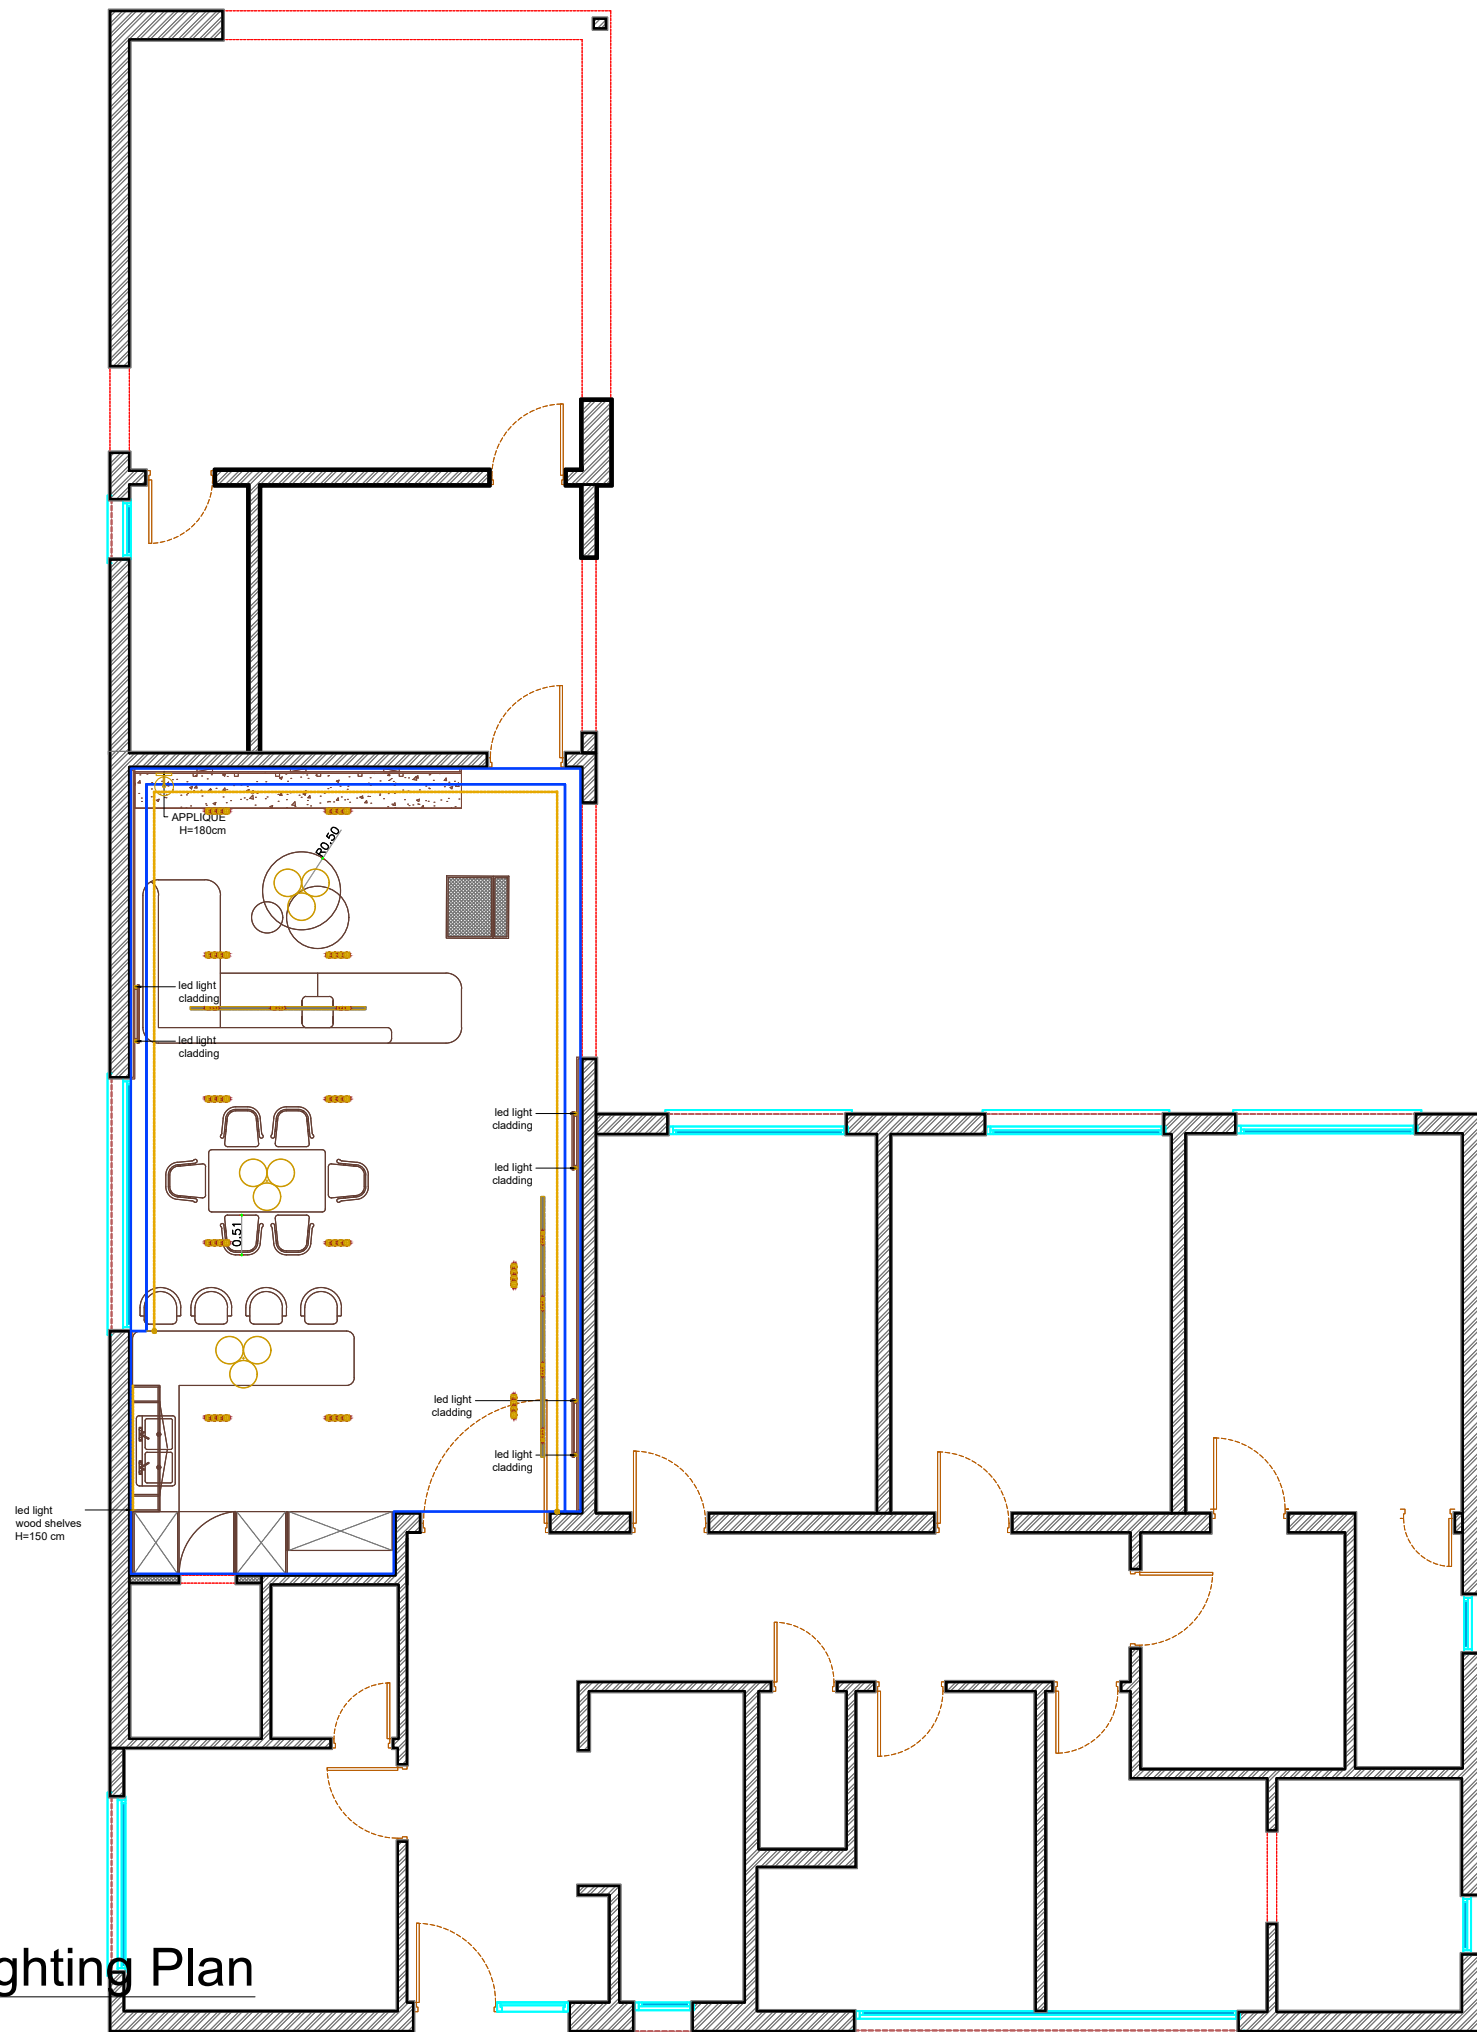

Ceiling & Wall Lighting Plan

GENERAL NOTES

1. ALL DIMENSIONS ARE IN METERS UNLESS OTHERWISE STATED.
2. VERIFY THE ARCHITECT WHENEVER DISCREPANCIES ARE FOUND BETWEEN DRAWINGS AND SPECIFICATIONS.
3. DO NOT SCALE FROM THIS DRAWING, WORK TO FIGURE DIMENSIONS ONLY.
4. COMPLETE WORKING DRAWINGS SHALL BE SUBMITTED BY THE CONTRACTOR FOR CONSULTANT APPROVAL BEFORE EXECUTION.
5. DRAWING TO BE READ IN CO-ORDINATION AND IN CONJUNCTION WITH ALL RELEVANT SPECIFICATIONS AND CROSS DISCIPLINE ENGINEERING DRAWINGS INCLUDING LANDSCAPING.
6. ALL ELECTRO-MECHANICAL WORKS SHALL BE COORDINATED WITH ARCHITECTURAL ELEMENTS IN THESE DRAWING (MASONRY, FLOORING, CEILING, OPENINGS, LIGHTING, ETC.)
7. CONTRACTOR SHALL SUBMIT FINISHING MATERIAL SAMPLES FOR CONSULTANT APPROVAL BEFORE EXECUTION.

REVISIONS:

NO.	DERIPTION	DATE

CLIENT: -


PROJECT: -

LOCATION: -

DRAWING TITLE: -

DATE: -	SHEET 5
SCALE: -	

Ceiling & Wall Lighting (DIMs) Plan

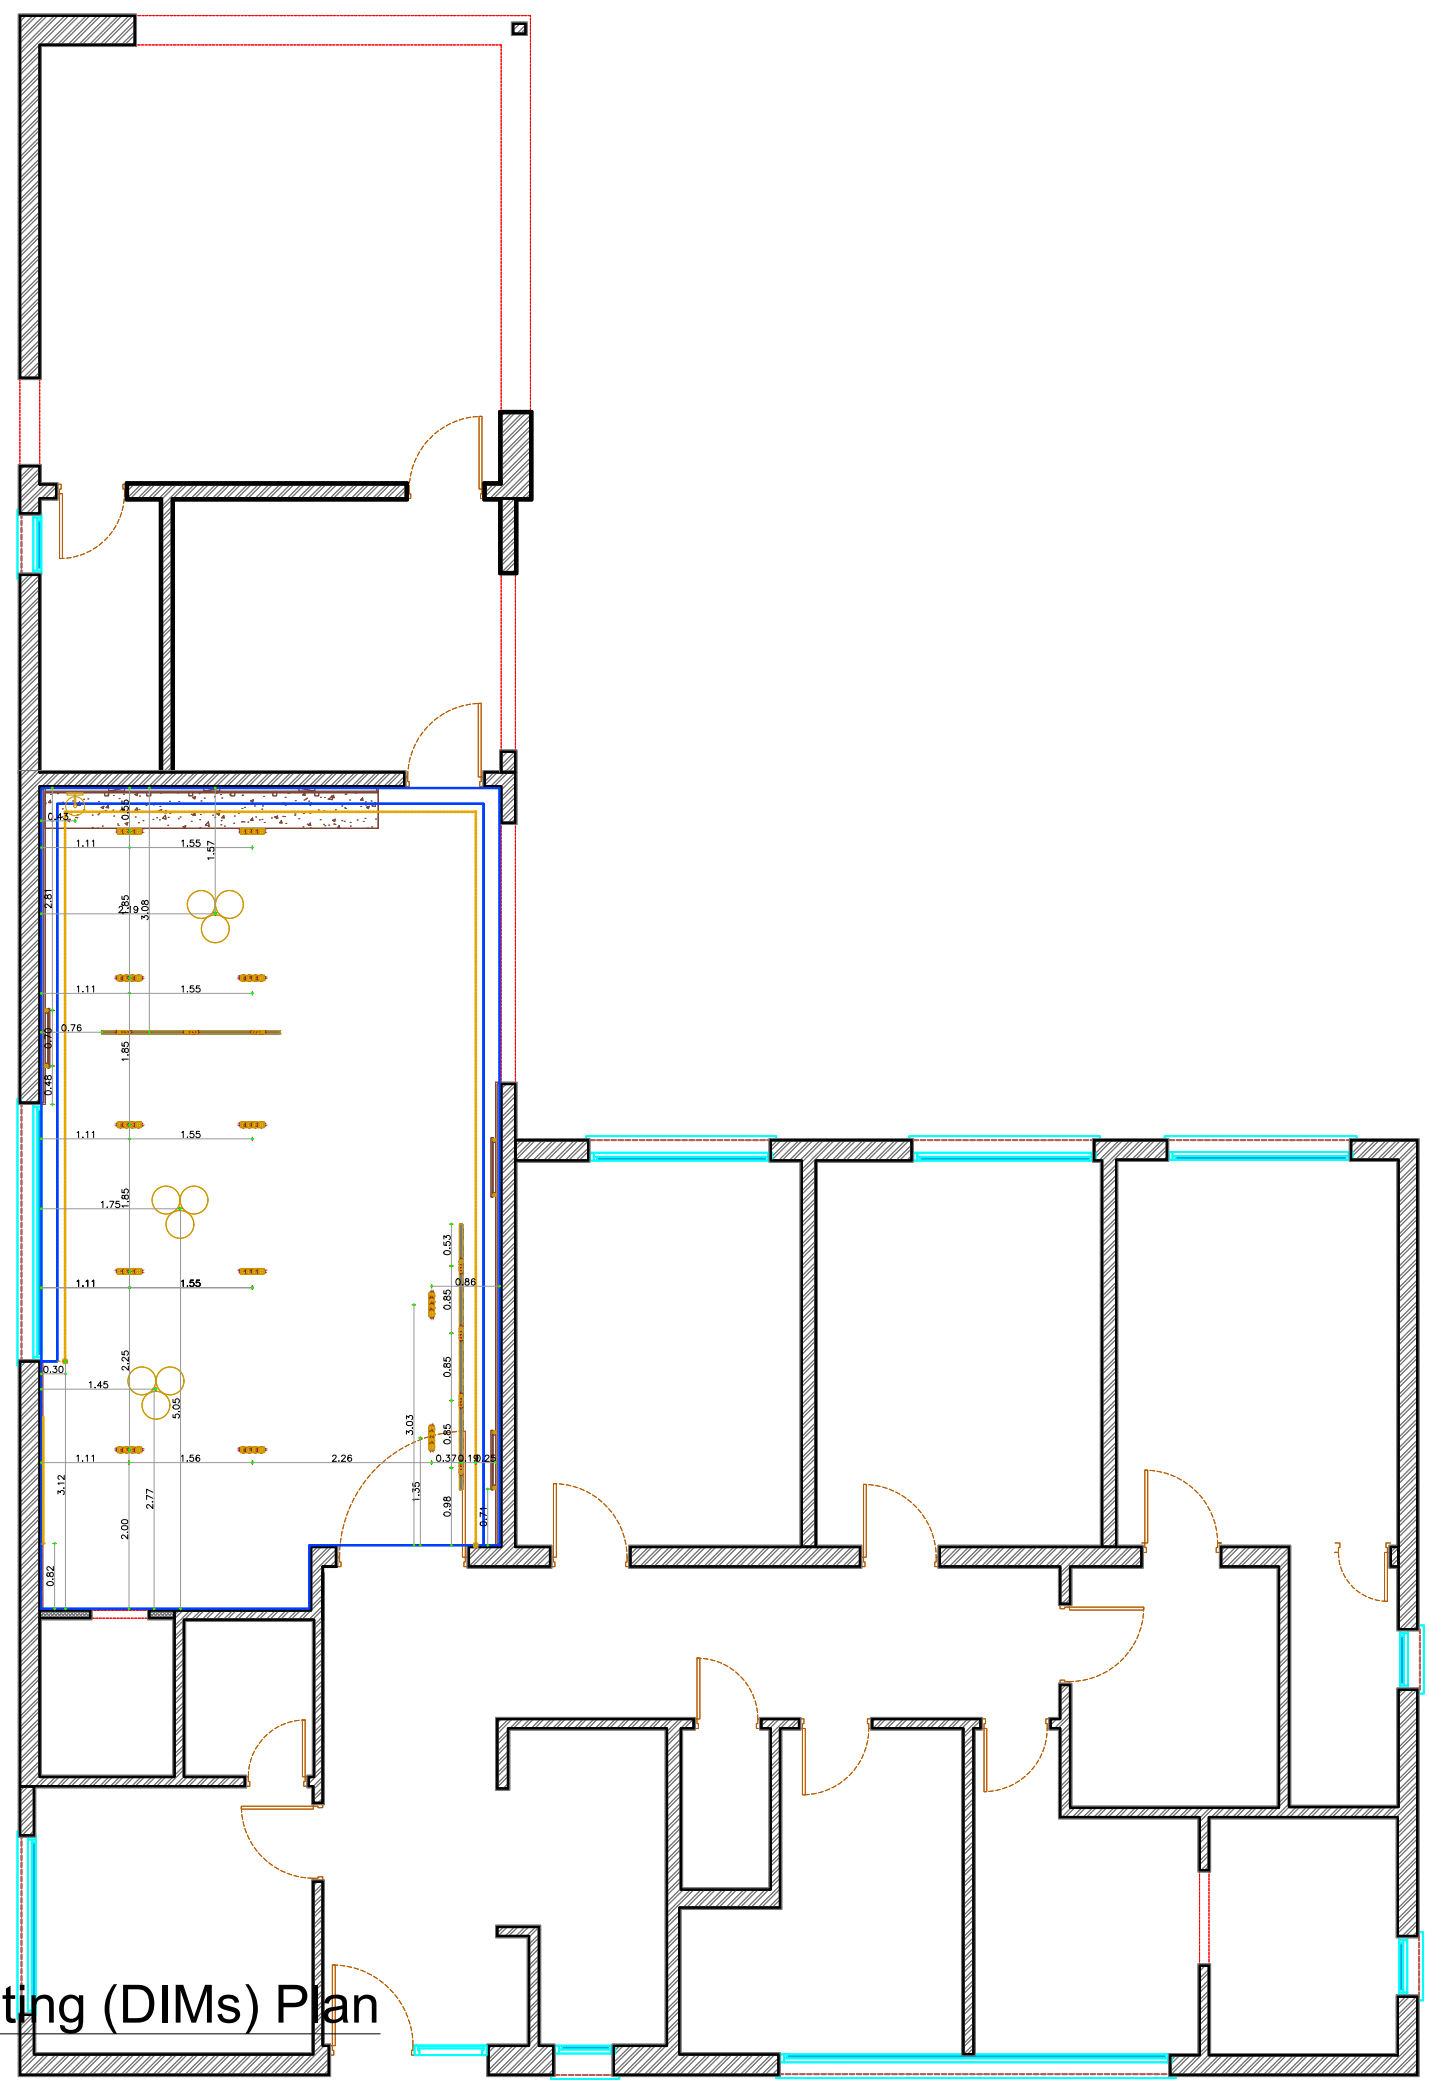

- GENERAL NOTES**
1. ALL DIMENSIONS ARE IN METERS UNLESS OTHERWISE STATED.
 2. VERIFY THE ARCHITECT WHENEVER DISCREPANCIES ARE FOUND BETWEEN DRAWINGS AND SPECIFICATIONS.
 3. DO NOT SCALE FROM THIS DRAWING, WORK TO FIGURE DIMENSIONS ONLY.
 4. COMPLETE WORKING DRAWINGS SHALL BE SUBMITTED BY THE CONTRACTOR FOR CONSULTANT APPROVAL BEFORE EXECUTION.
 5. DRAWING TO BE READ IN CO-ORDINATION AND IN CONJUNCTION WITH ALL RELEVANT SPECIFICATIONS AND CROSS DISCIPLINE ENGINEERING DRAWINGS INCLUDING LANDSCAPING.
 6. ALL ELECTRO-MECHANICAL WORKS SHALL BE COORDINATED WITH ARCHITECTURAL ELEMENTS IN THESE DRAWING (MASONRY, FLOORING, CEILING, OPENINGS, LIGHTING, ETC.)
 7. CONTRACTOR SHALL SUBMIT FINISHING MATERIAL SAMPLES FOR CONSULTANT APPROVAL BEFORE EXECUTION.

REVISIONS:

NO.	DESCRIPTION	DATE

CLIENT: -


PROJECT: -

LOCATION: -

DRAWING TITLE: -

DATE: -	SHEET 6
SCALE: -	

Power Plan

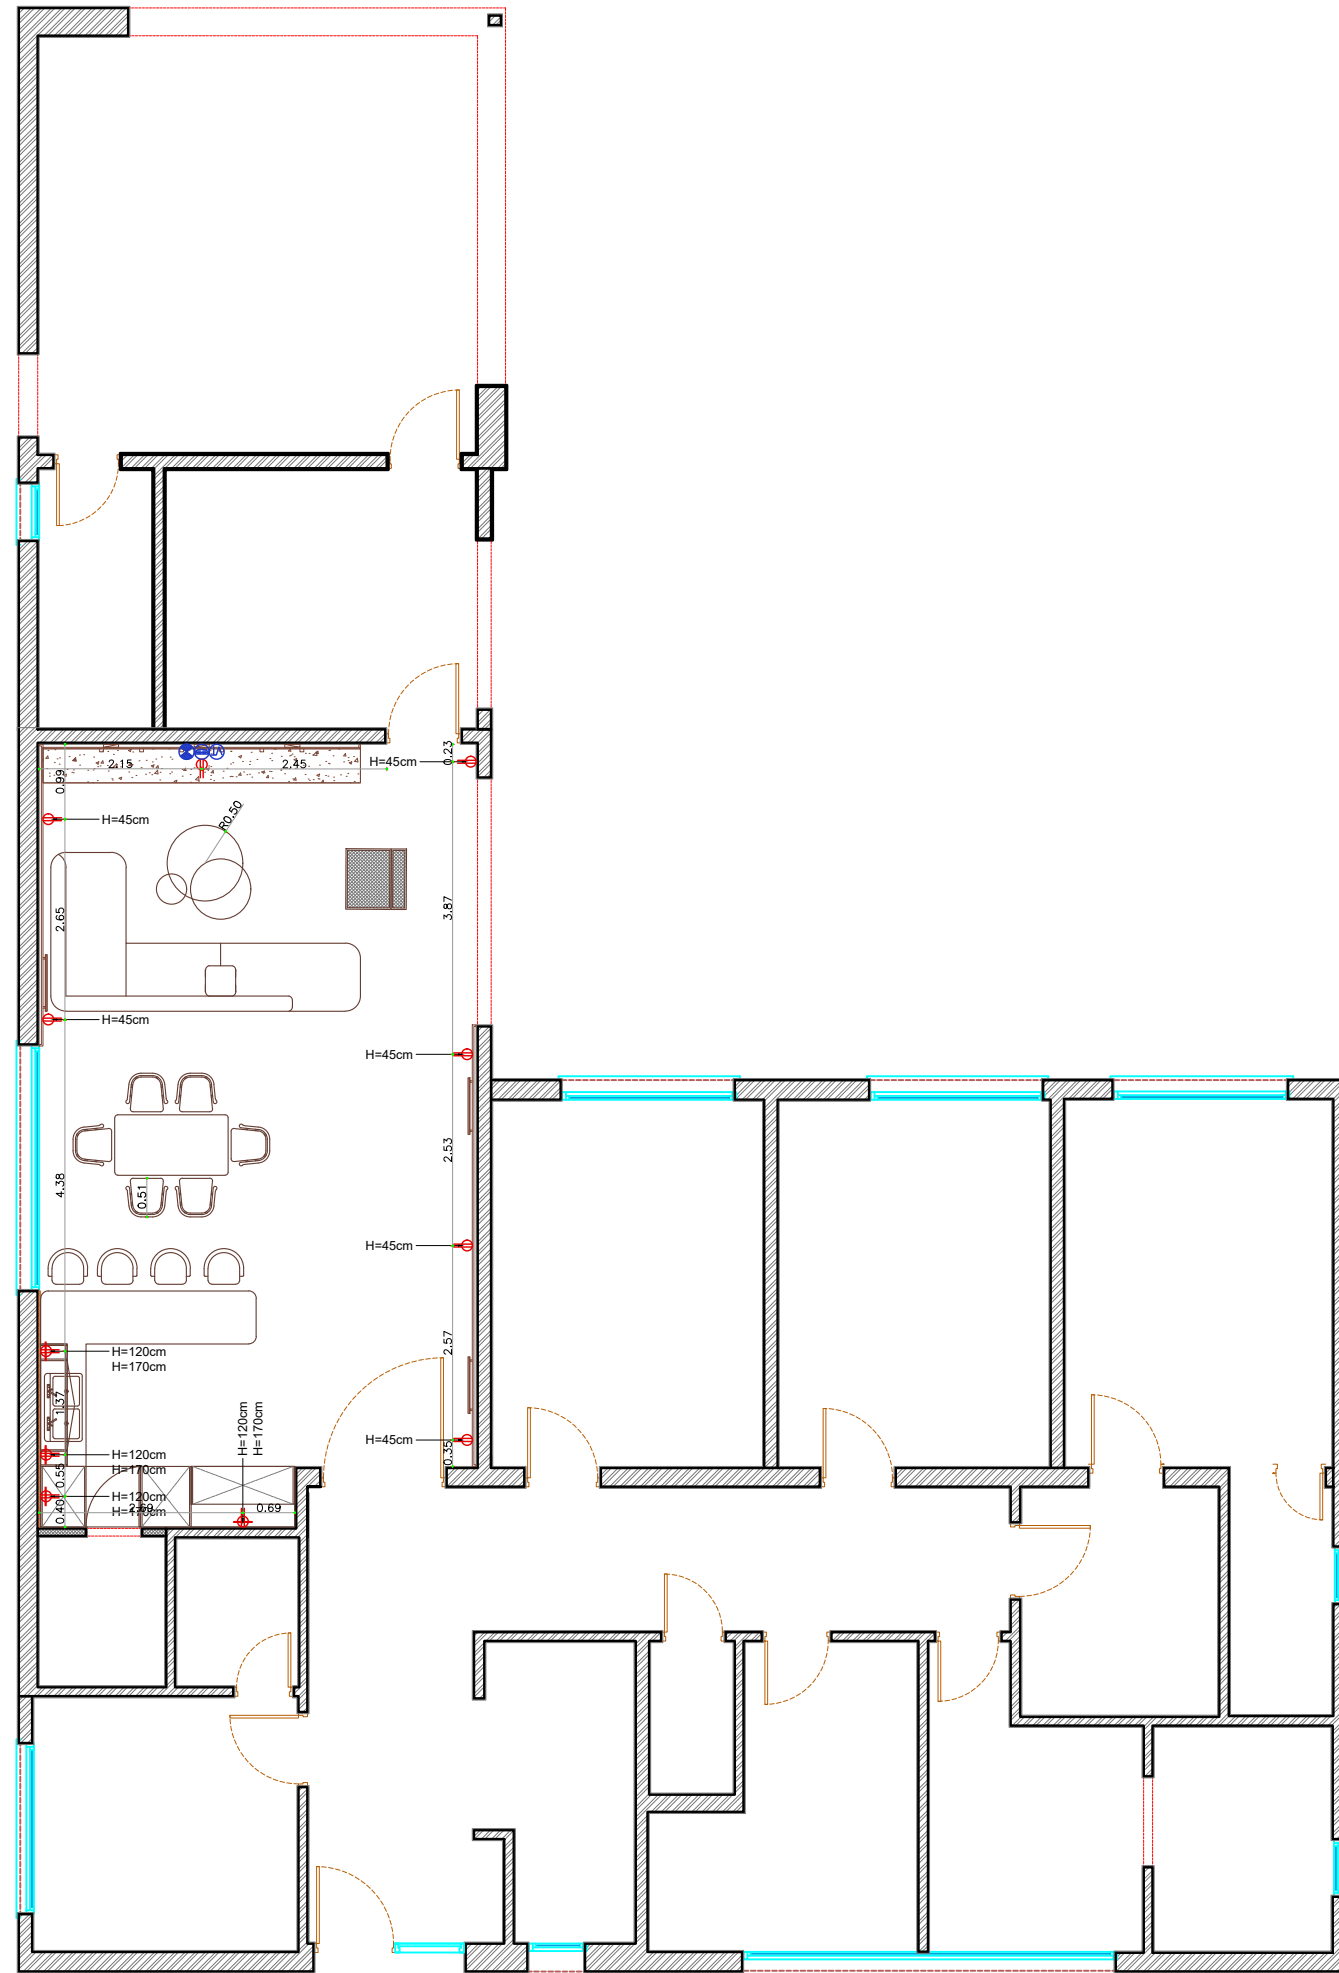

GENERAL NOTES

1. ALL DIMENSIONS ARE IN METERS UNLESS OTHERWISE STATED.
2. VERIFY THE ARCHITECT WHENEVER DISCREPANCIES ARE FOUND BETWEEN DRAWINGS AND SPECIFICATIONS.
3. DO NOT SCALE FROM THIS DRAWING, WORK TO FIGURE DIMENSIONS ONLY.
4. COMPLETE WORKING DRAWINGS SHALL BE SUBMITTED BY THE CONTRACTOR FOR CONSULTANT APPROVAL BEFORE EXECUTION.
5. DRAWING TO BE READ IN CO-ORDINATION AND IN CONJUNCTION WITH ALL RELEVANT SPECIFICATIONS AND CROSS DISCIPLINE ENGINEERING DRAWINGS INCLUDING LANDSCAPING.
6. ALL ELECTRO-MECHANICAL WORKS SHALL BE COORDINATED WITH ARCHITECTURAL ELEMENTS IN THESE DRAWING (MASONRY, FLOORING, CEILING, OPENINGS, LIGHTING, ETC.)
7. CONTRACTOR SHALL SUBMIT FINISHING MATERIAL SAMPLES FOR CONSULTANT APPROVAL BEFORE EXECUTION.

REVISIONS:

NO.	DESCRIPTION	DATE

- ALL SOCKETS HEIGHT AT 45cm FROM FINISHING.
- OTHER HEIGHTS MENTIONED.

	SOCKET
	POWER SOCKET
	SUCTION
	SHUTTER
	TELEPHONE
	DATA ENTRY
	T.V. ENTRY
	USB ENTRY

CLIENT: -


PROJECT: -

LOCATION: -

DRAWING TITLE: -

DATE: -	SHEET 7
SCALE: -	

Switches Plan

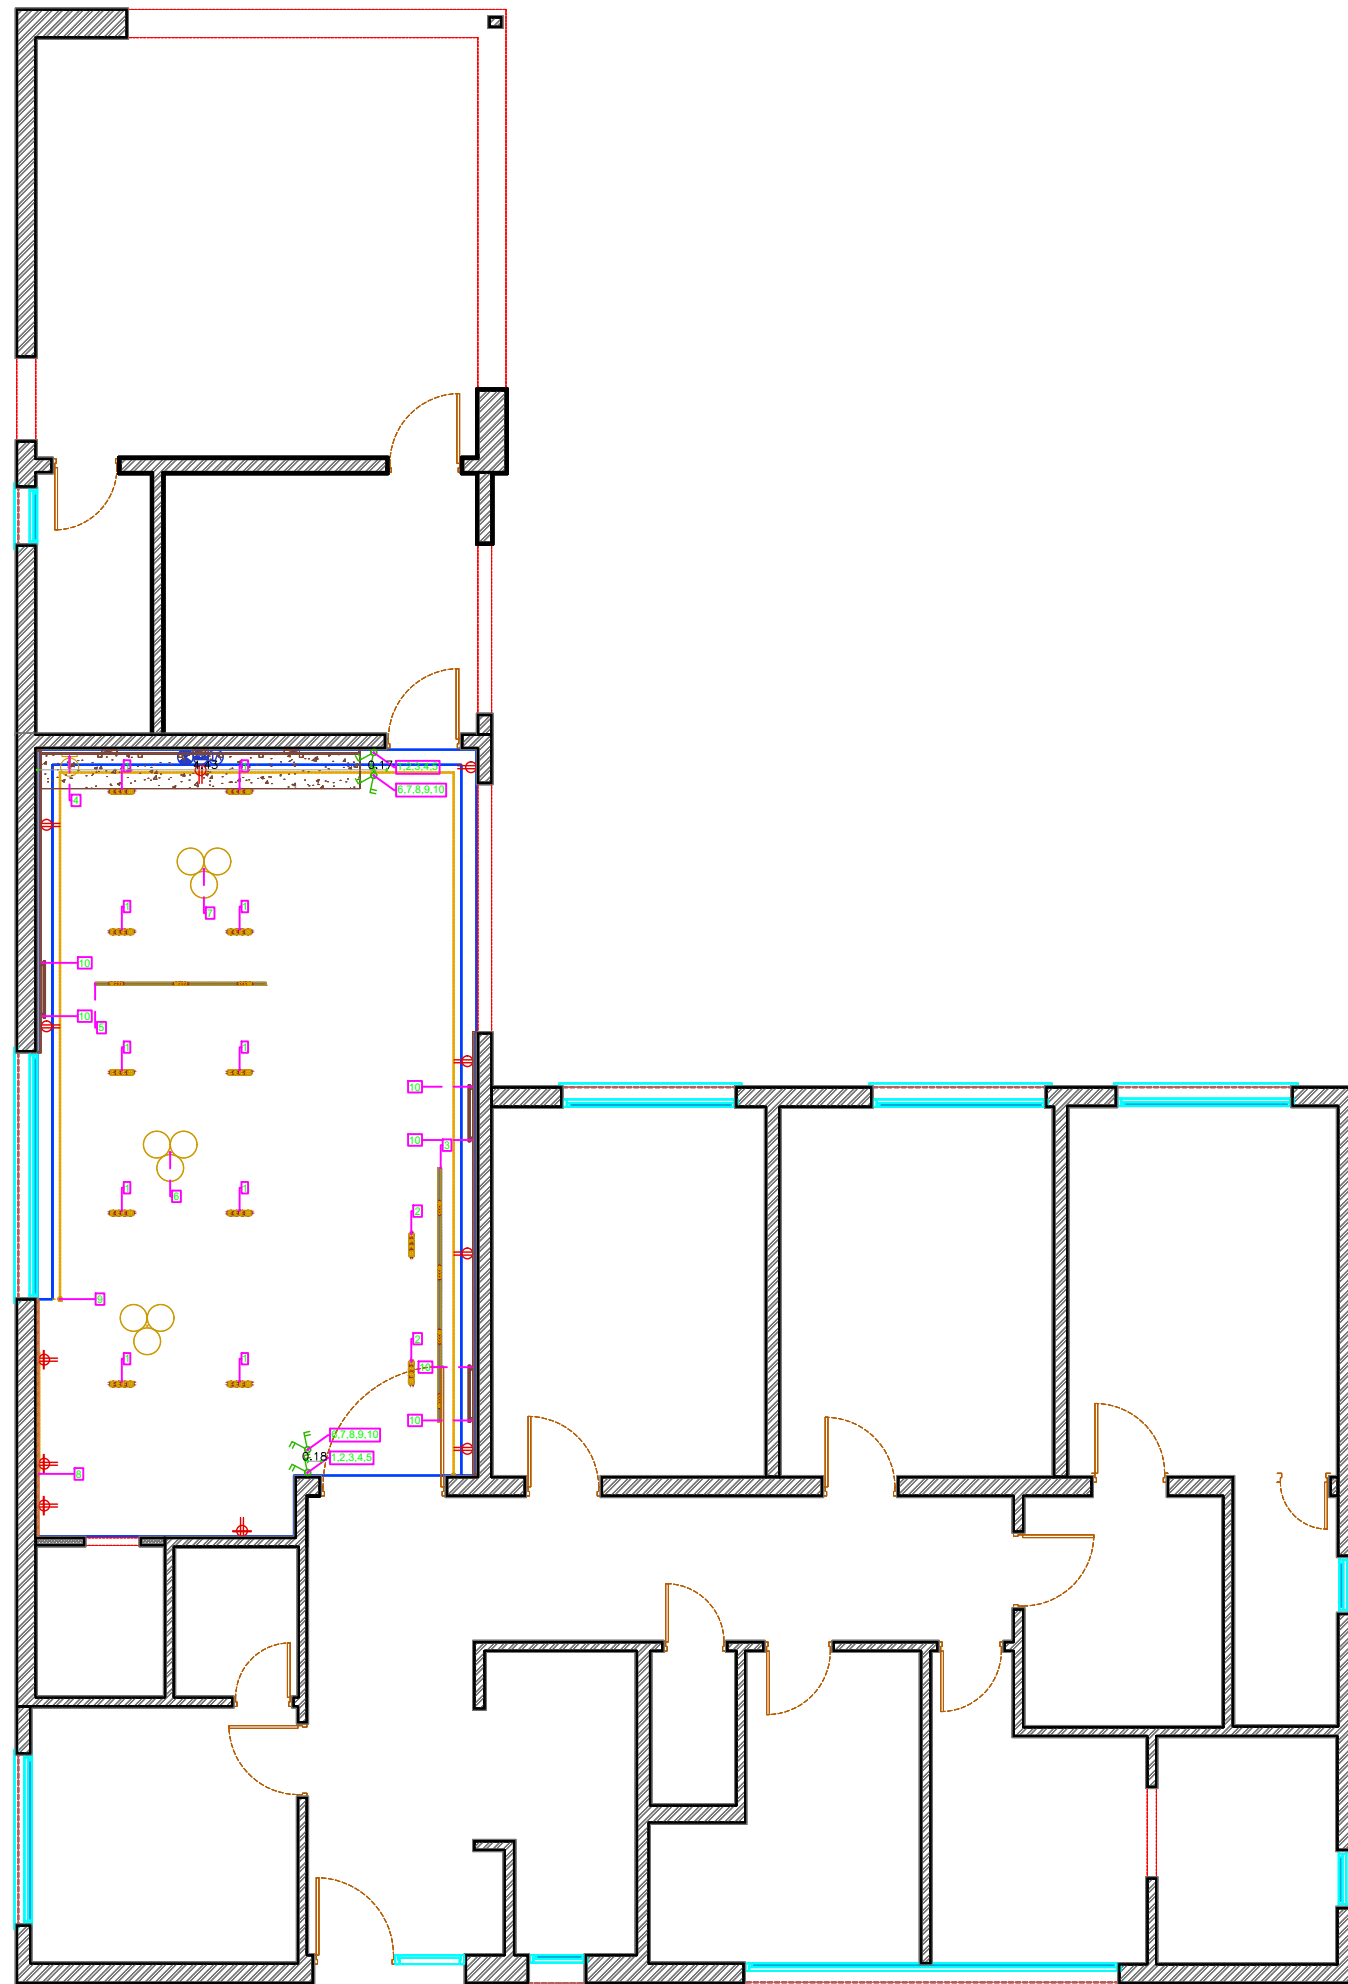

GENERAL NOTES

1. ALL DIMENSIONS ARE IN METERS UNLESS OTHERWISE STATED.
2. VERIFY THE ARCHITECT WHENEVER DISCREPANCIES ARE FOUND BETWEEN DRAWINGS AND SPECIFICATIONS.
3. DO NOT SCALE FROM THIS DRAWING, WORK TO FIGURE DIMENSIONS ONLY.
4. COMPLETE WORKING DRAWINGS SHALL BE SUBMITTED BY THE CONTRACTOR FOR CONSULTANT APPROVAL BEFORE EXECUTION.
5. DRAWING TO BE READ IN CO-ORDINATION AND IN CONJUNCTION WITH ALL RELEVANT SPECIFICATIONS AND CROSS DISCIPLINE ENGINEERING DRAWINGS INCLUDING LANDSCAPING.
6. ALL ELECTRO-MECHANICAL WORKS SHALL BE COORDINATED WITH ARCHITECTURAL ELEMENTS IN THESE DRAWING (MASONRY, FLOORING, CEILING, OPENINGS, LIGHTING, ETC.)
7. CONTRACTOR SHALL SUBMIT FINISHING MATERIAL SAMPLES FOR CONSULTANT APPROVAL BEFORE EXECUTION.


REVISIONS:

NO.	DESCRIPTION	DATE

- ALL SWITCHES HEIGHT AT 120cm. - OTHER HEIGHTS MENTIONED. - ALL HEIGHTS FROM FINISHING.	
	ONE GANG, TWO WAYS SWITCH
	TWO GANGS, TWO WAYS SWITCH
	THREE GANGS, TWO WAYS SWITCH
	ONE GANG, ONE WAY SWITCH
	TWO GANGS, ONE WAY SWITCH
	THREE GANGS, ONE WAY SWITCH

CLIENT:	-
PROJECT:	-
LOCATION:	-
DRAWING TITLE:	-

DATE:	-	SHEET 8
SCALE:	-	

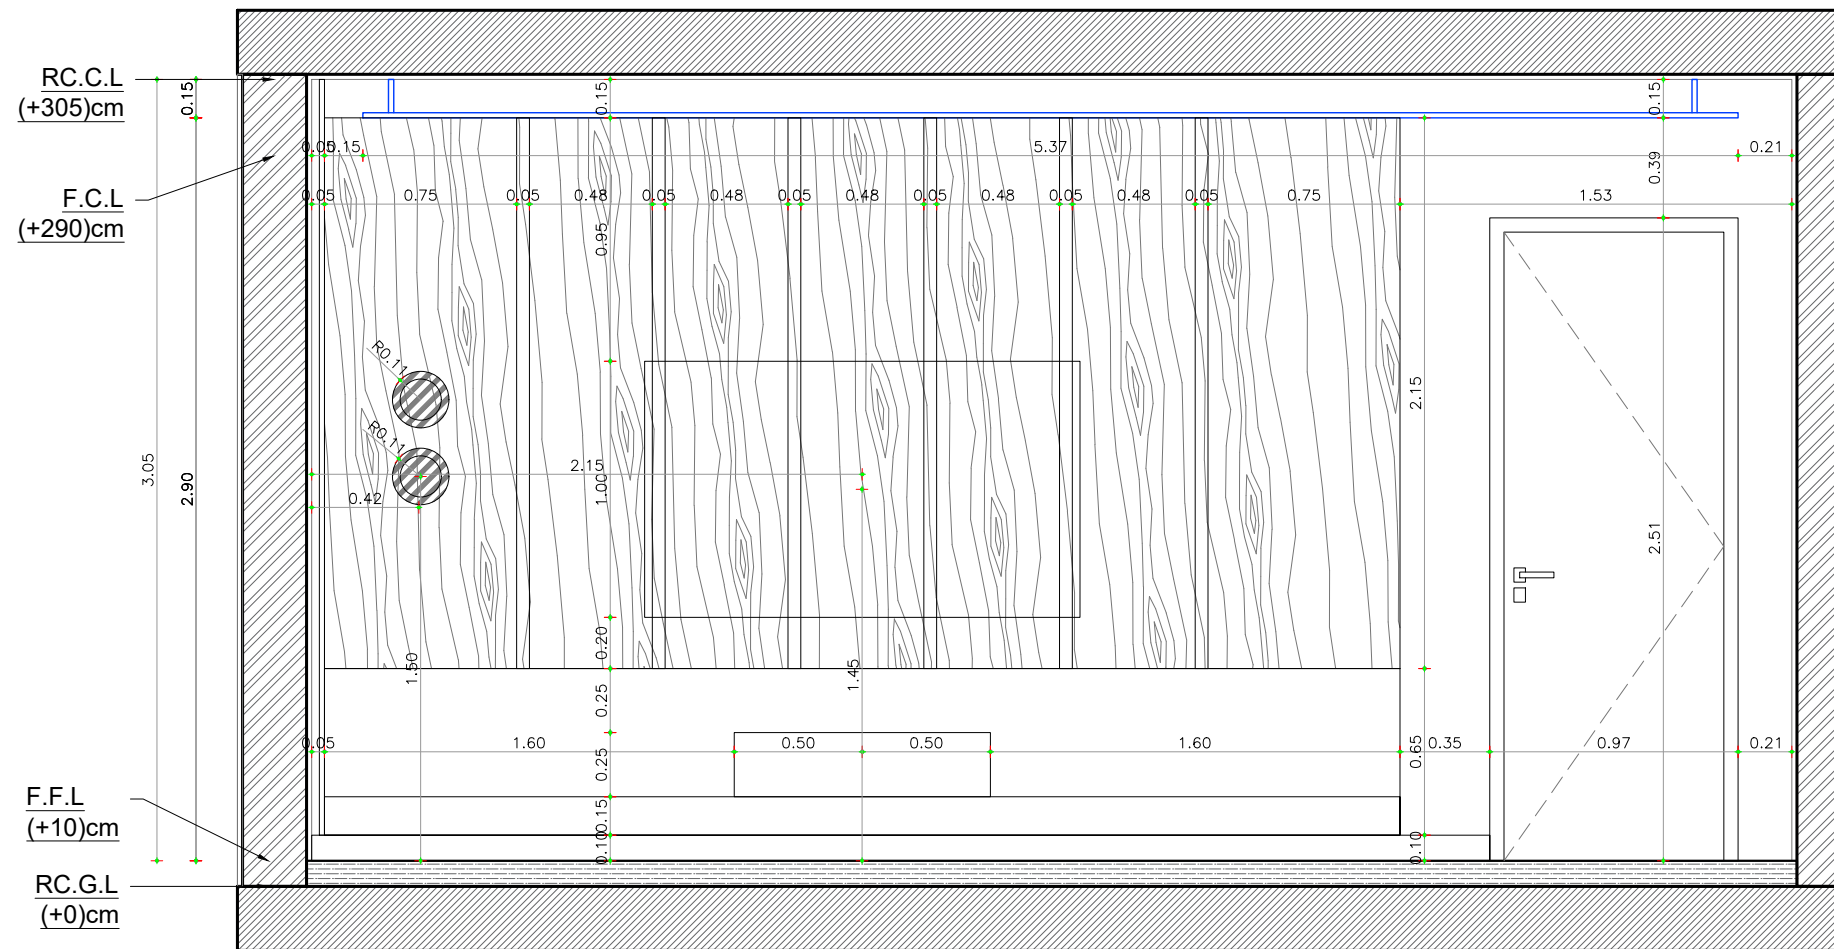


LIVING ROOM&KITCHEN
SECTION (2)

GENERAL NOTES

1. ALL DIMENSIONS ARE IN METERS UNLESS OTHERWISE STATED.
2. VERIFY THE ARCHITECT WHENEVER DISCREPANCIES ARE FOUND BETWEEN DRAWINGS AND SPECIFICATIONS.
3. DO NOT SCALE FROM THIS DRAWING, WORK TO FIGURE DIMENSIONS ONLY.
4. COMPLETE WORKING DRAWINGS SHALL BE SUBMITTED BY THE CONTRACTOR FOR CONSULTANT APPROVAL BEFORE EXECUTION.
5. DRAWING TO BE READ IN CO-ORDINATION AND IN CONJUNCTION WITH ALL RELEVANT SPECIFICATIONS AND CROSS DISCIPLINE ENGINEERING DRAWINGS INCLUDING LANDSCAPING.
6. ALL ELECTRO-MECHANICAL WORKS SHALL BE COORDINATED WITH ARCHITECTURAL ELEMENTS IN THESE DRAWING (MASONRY, FLOORING, CEILING, OPENINGS, LIGHTING, ETC.)
7. CONTRACTOR SHALL SUBMIT FINISHING MATERIAL SAMPLES FOR CONSULTANT APPROVAL BEFORE EXECUTION.

REVISIONS:

NO.	DESCRIPTION	DATE

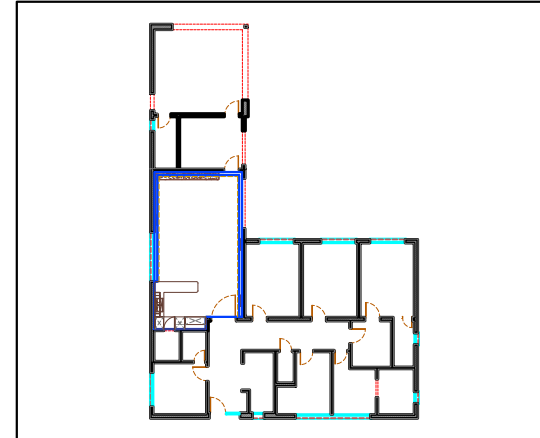

CLIENT: -

PROJECT: -

LOCATION: -

DRAWING TITLE: -

DATE: -	SHEET 01
SCALE: -	




GENERAL NOTES

1. ALL DIMENSIONS ARE IN METERS UNLESS OTHERWISE STATED.
2. VERIFY THE ARCHITECT WHENEVER DISCREPANCIES ARE FOUND BETWEEN DRAWINGS AND SPECIFICATIONS.
3. DO NOT SCALE FROM THIS DRAWING, WORK TO FIGURE DIMENSIONS ONLY.
4. COMPLETE WORKING DRAWINGS SHALL BE SUBMITTED BY THE CONTRACTOR FOR CONSULTANT APPROVAL BEFORE EXECUTION.
5. DRAWING TO BE READ IN CO-ORDINATION AND IN CONJUNCTION WITH ALL RELEVANT SPECIFICATIONS AND CROSS DISCIPLINE ENGINEERING DRAWINGS INCLUDING LANDSCAPING.
6. ALL ELECTRO-MECHANICAL WORKS SHALL BE COORDINATED WITH ARCHITECTURAL ELEMENTS IN THESE DRAWING (MASONRY, FLOORING, CEILING, OPENINGS, LIGHTING, ETC.)
7. CONTRACTOR SHALL SUBMIT FINISHING MATERIAL SAMPLES FOR CONSULTANT APPROVAL BEFORE EXECUTION.

REVISIONS:

NO.	DESCRIPTION	DATE

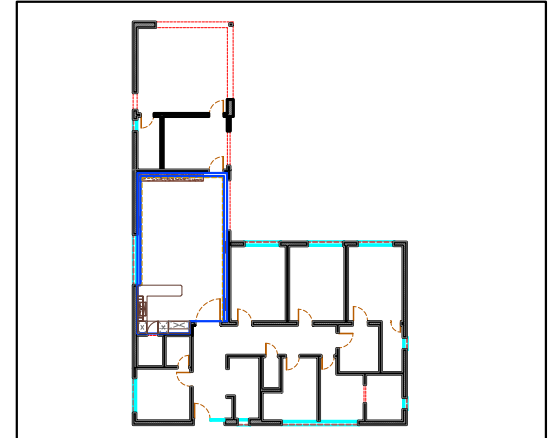


CLIENT: -

PROJECT: -

LOCATION: -

DRAWING TITLE: -

DATE: -	SHEET 02
SCALE: -	

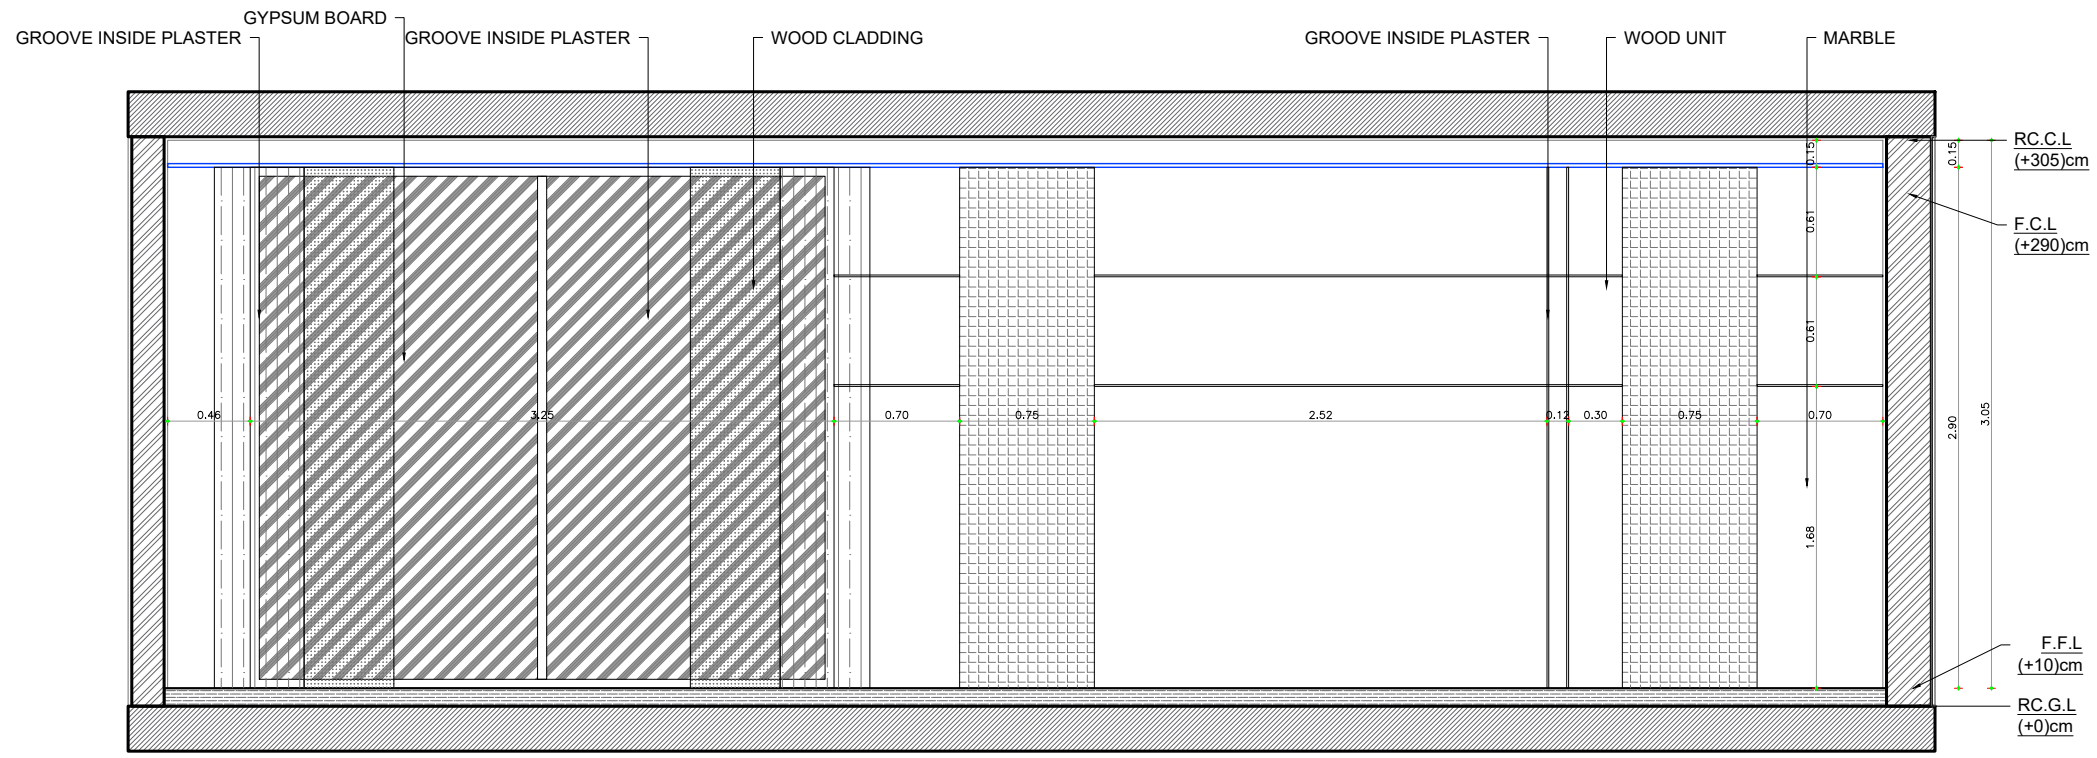

LIVING ROOM&KITCHEN
SECTION (2)




GENERAL NOTES


1. ALL DIMENSIONS ARE IN METERS UNLESS OTHERWISE STATED.
2. VERIFY THE ARCHITECT WHENEVER DISCREPANCIES ARE FOUND BETWEEN DRAWINGS AND SPECIFICATIONS.
3. DO NOT SCALE FROM THIS DRAWING, WORK TO FIGURE DIMENSIONS ONLY.
4. COMPLETE WORKING DRAWINGS SHALL BE SUBMITTED BY THE CONTRACTOR FOR CONSULTANT APPROVAL BEFORE EXECUTION.
5. DRAWING TO BE READ IN CO-ORDINATION AND IN CONJUNCTION WITH ALL RELEVANT SPECIFICATIONS AND CROSS DISCIPLINE ENGINEERING DRAWINGS INCLUDING LANDSCAPING.
6. ALL ELECTRO-MECHANICAL WORKS SHALL BE COORDINATED WITH ARCHITECTURAL ELEMENTS IN THESE DRAWING (MASONRY, FLOORING, CEILING, OPENINGS, LIGHTING, ETC.)
7. CONTRACTOR SHALL SUBMIT FINISHING MATERIAL SAMPLES FOR CONSULTANT APPROVAL BEFORE EXECUTION.

REVISIONS:

NO.	DESCRIPTION	DATE

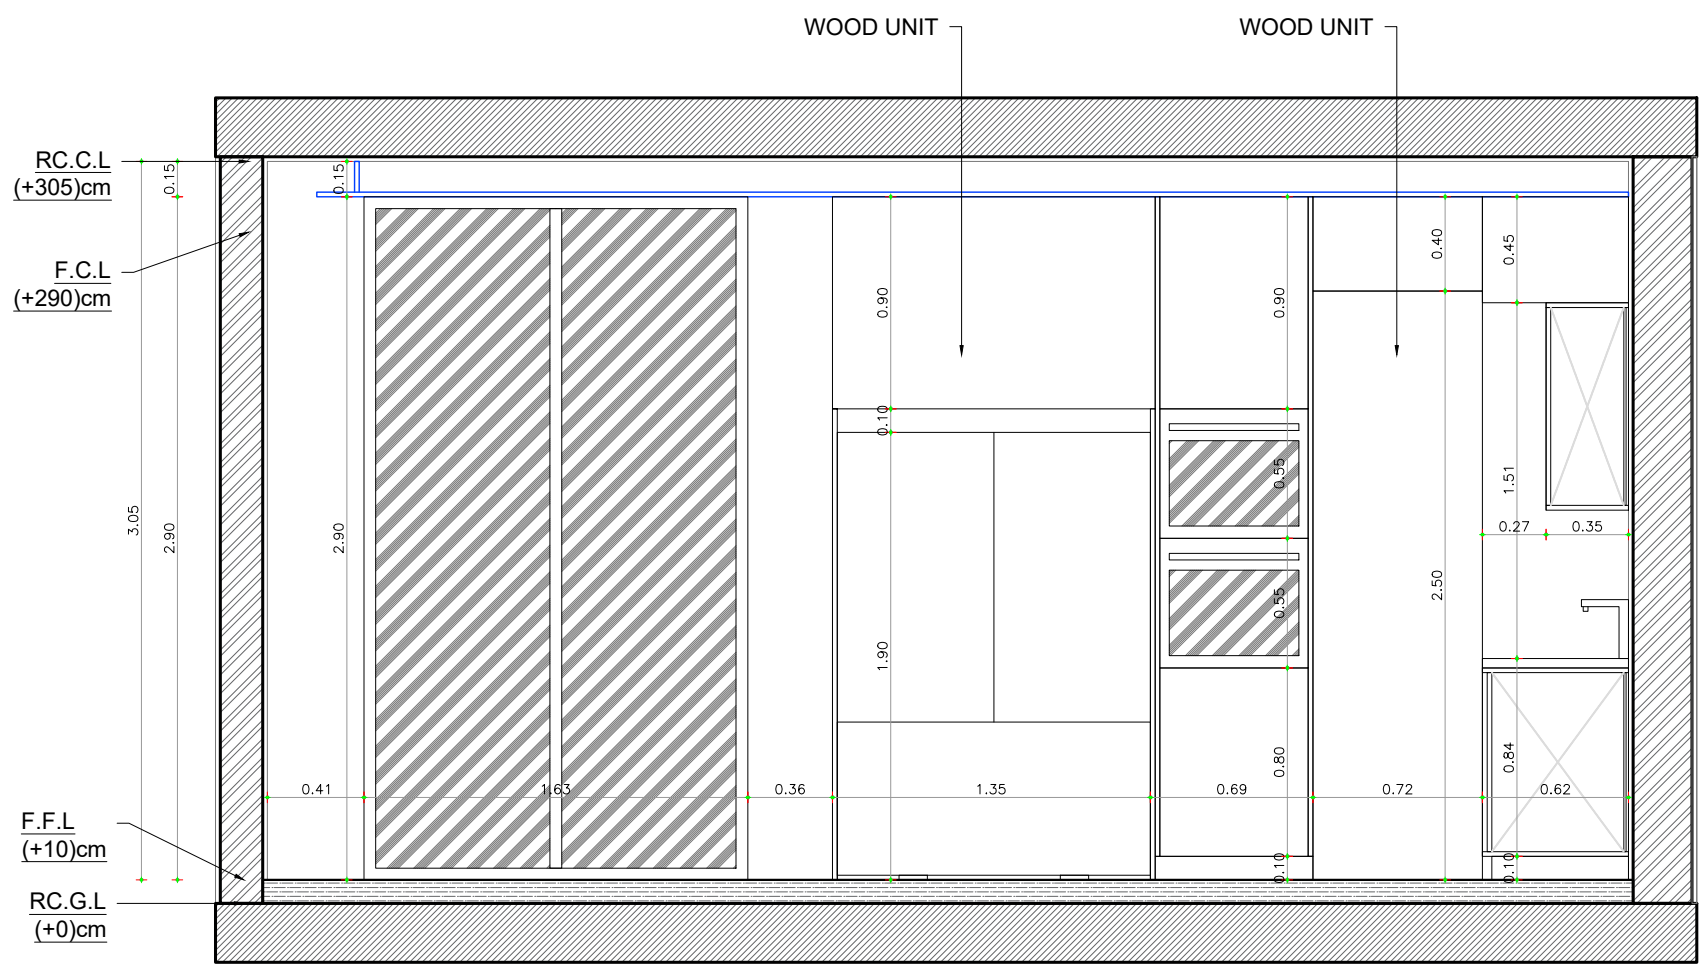

LIVING ROOM&KITCHEN SECTION (3)

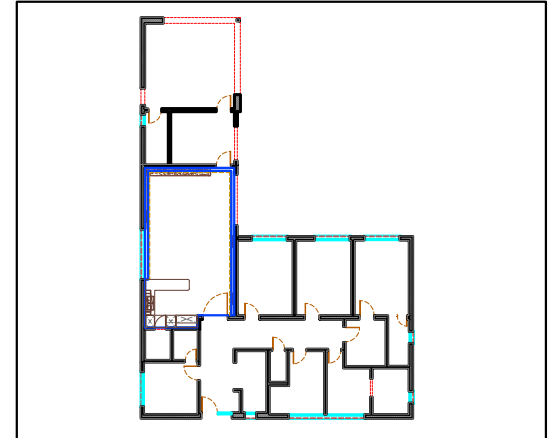

CLIENT: -

PROJECT: -

LOCATION: -

DRAWING TITLE: -

DATE: -	SHEET 03
SCALE: -	




GENERAL NOTES


1. ALL DIMENSIONS ARE IN METERS UNLESS OTHERWISE STATED.
2. VERIFY THE ARCHITECT WHENEVER DISCREPANCIES ARE FOUND BETWEEN DRAWINGS AND SPECIFICATIONS.
3. DO NOT SCALE FROM THIS DRAWING, WORK TO FIGURE DIMENSIONS ONLY.
4. COMPLETE WORKING DRAWINGS SHALL BE SUBMITTED BY THE CONTRACTOR FOR CONSULTANT APPROVAL BEFORE EXECUTION.
5. DRAWING TO BE READ IN CO-ORDINATION AND IN CONJUNCTION WITH ALL RELEVANT SPECIFICATIONS AND CROSS DISCIPLINE ENGINEERING DRAWINGS INCLUDING LANDSCAPING.
6. ALL ELECTRO-MECHANICAL WORKS SHALL BE COORDINATED WITH ARCHITECTURAL ELEMENTS IN THESE DRAWING (MASONRY, FLOORING, CEILING, OPENINGS, LIGHTING, ETC.)
7. CONTRACTOR SHALL SUBMIT FINISHING MATERIAL SAMPLES FOR CONSULTANT APPROVAL BEFORE EXECUTION.

REVISIONS:

NO.	DESCRIPTION	DATE

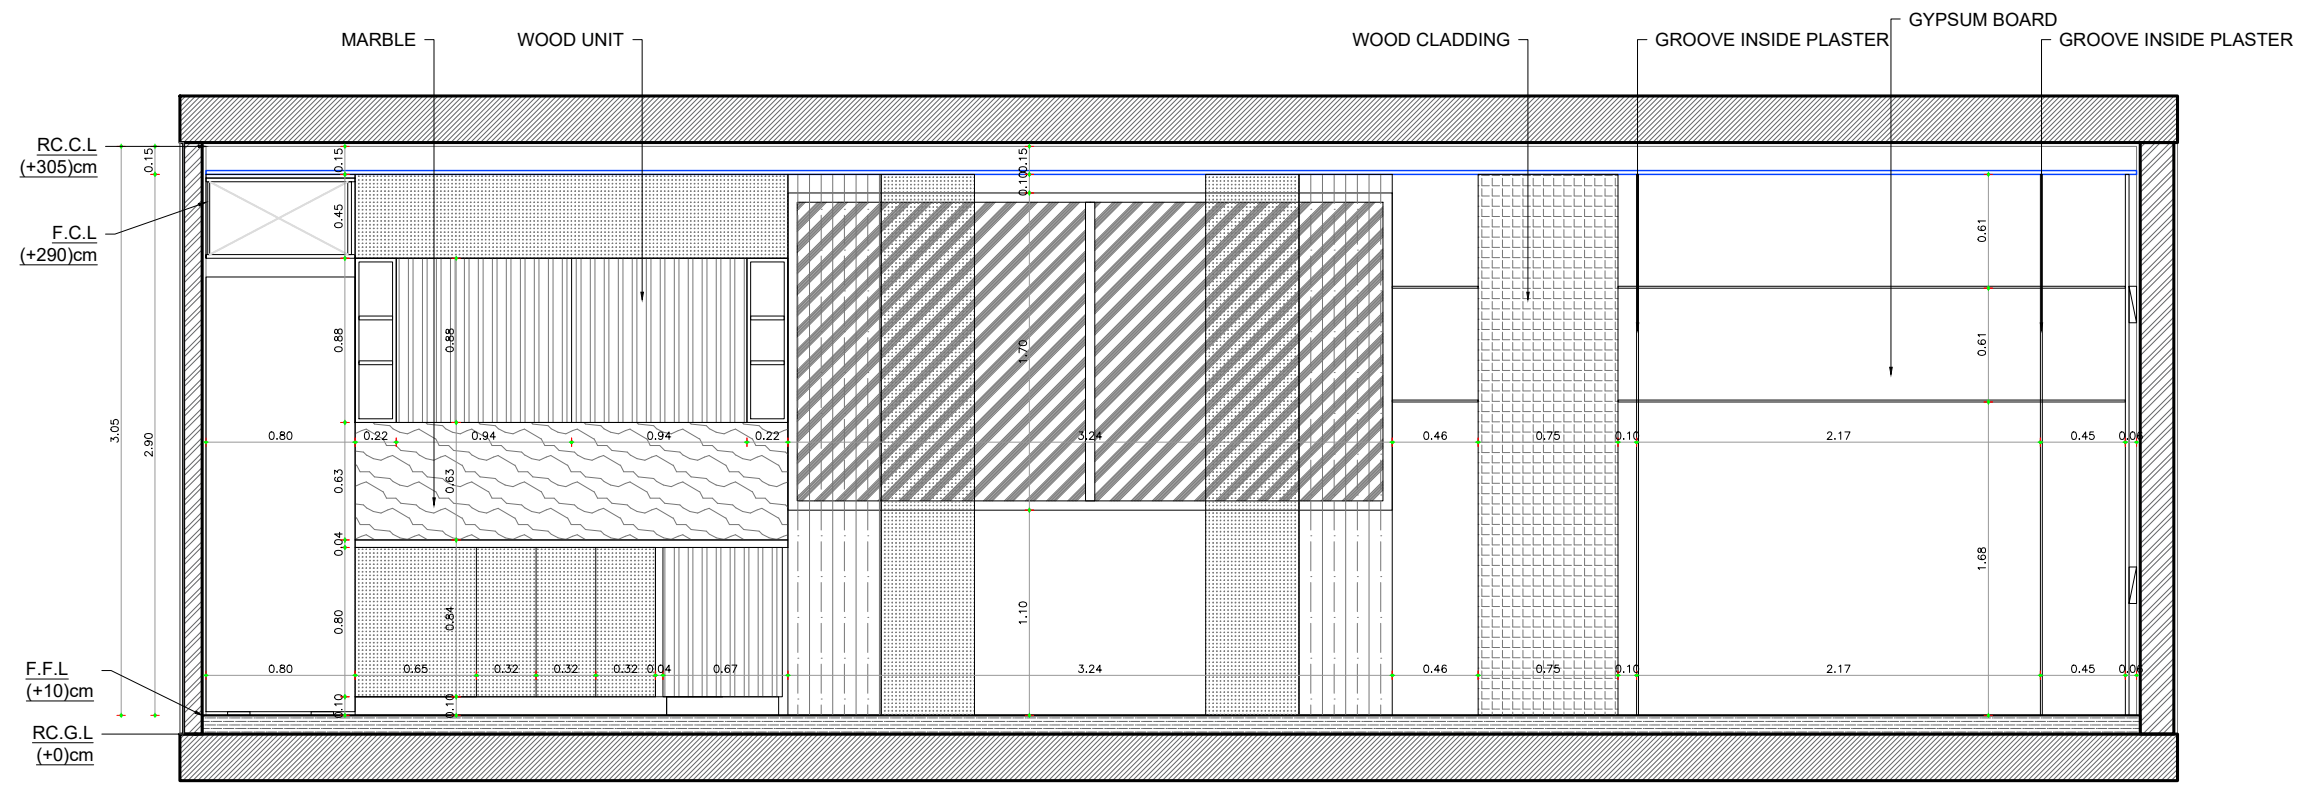

LIVING ROOM&KITCHEN SECTION (4)

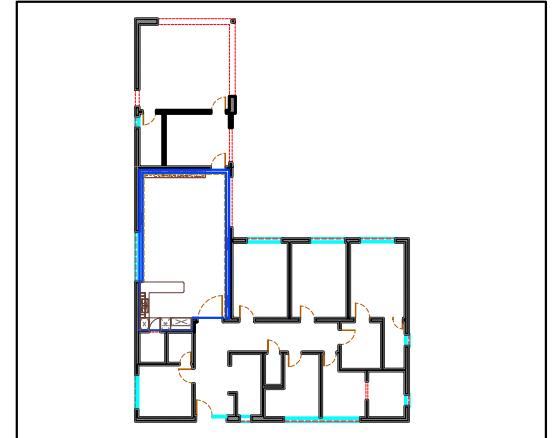

CLIENT:	-
PROJECT:	-
LOCATION:	-
DRAWING TITLE:	-

DATE:	-	SHEET 04
SCALE:	-	